


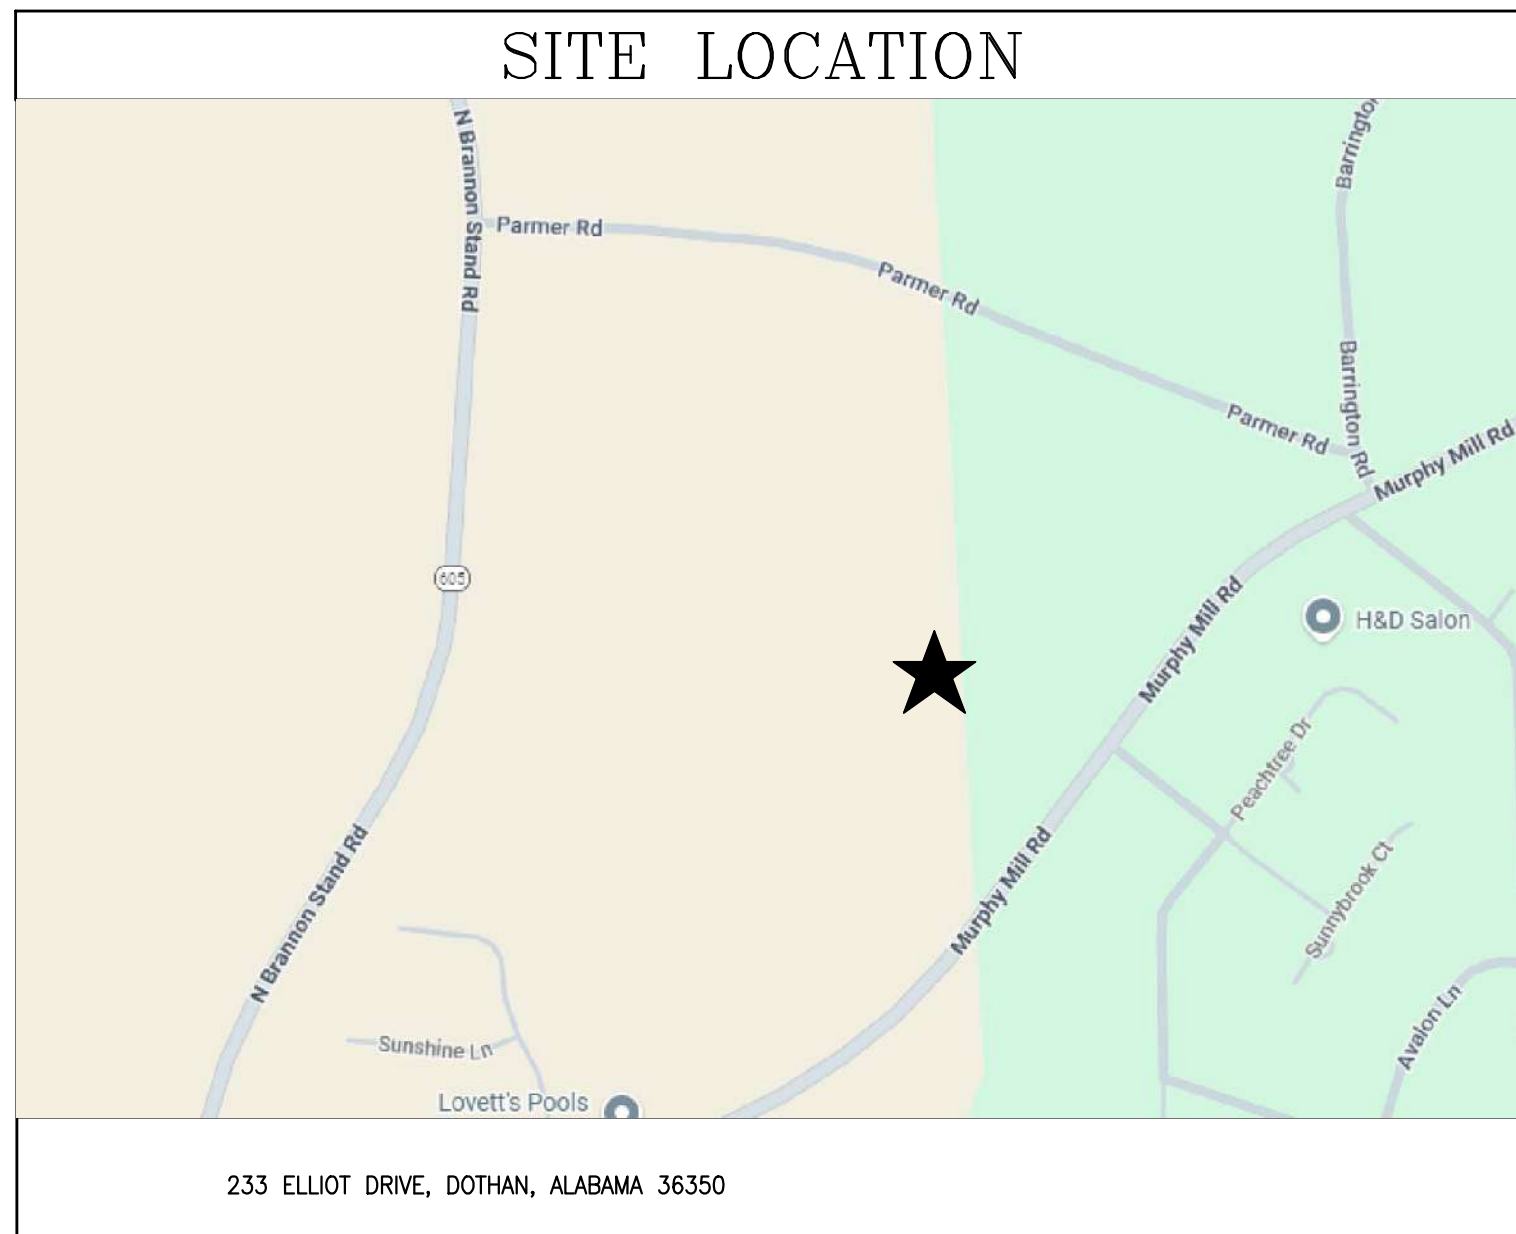

249 EASTON COURT

A REEVES AND SHAW HOME

DRAWINGS IN CONSTRUCTION SET					
INDEX PAGES					
A-1.000	INDEX	A-2.100	ROOF PLAN	L-2.010	MAIN LEVEL ELECTRICAL PLAN
A-1.100	SITE PLAN	A-3.000	ELEVATIONS	L-2.020	UPPER LEVEL ELECTRICAL
A-2.000	FOUNDATION PLAN	A-5.000	INTERIOR ELEVATIONS	A-8.000	SCHEDULE
A-2.001	GRADE BEAM PLAN	A-5.001	INTERIOR ELEVATIONS		
A-2.010	MAIN LEVEL FLOOR PLAN	A-5.002	INTERIOR ELEVATIONS		
A-2.020	UPPER LEVEL FLOOR PLAN	A-5.003	INTERIOR ELEVATIONS		



REVISION LOG:

NO.	DATE	REMARKS

DRAWN/CHECKED BY:

TC

INDEX FOR

249 EASTON COURT

A NEW RESIDENCE IN

DOTHAN, ALABAMA

RS

REEVES & SHAW
CONSTRUCTION

R&S CONSTRUCTION

REEVES AND SHAW CONSTRUCTION

Professional Consulting Engineers and Construction Services

3680 West Main Street - Dothan, Alabama 36305 334.677.5600

JOB NUMBER:

DATE:



February 26

SHEET TITLE & NO.

INDEX

A-1.000

**249 EASTON COURT
LOT 2 BLOCK F
THE RESERVE SUBDIVISION
DOTHAN, ALABAMA**

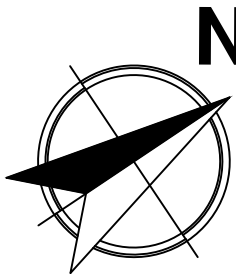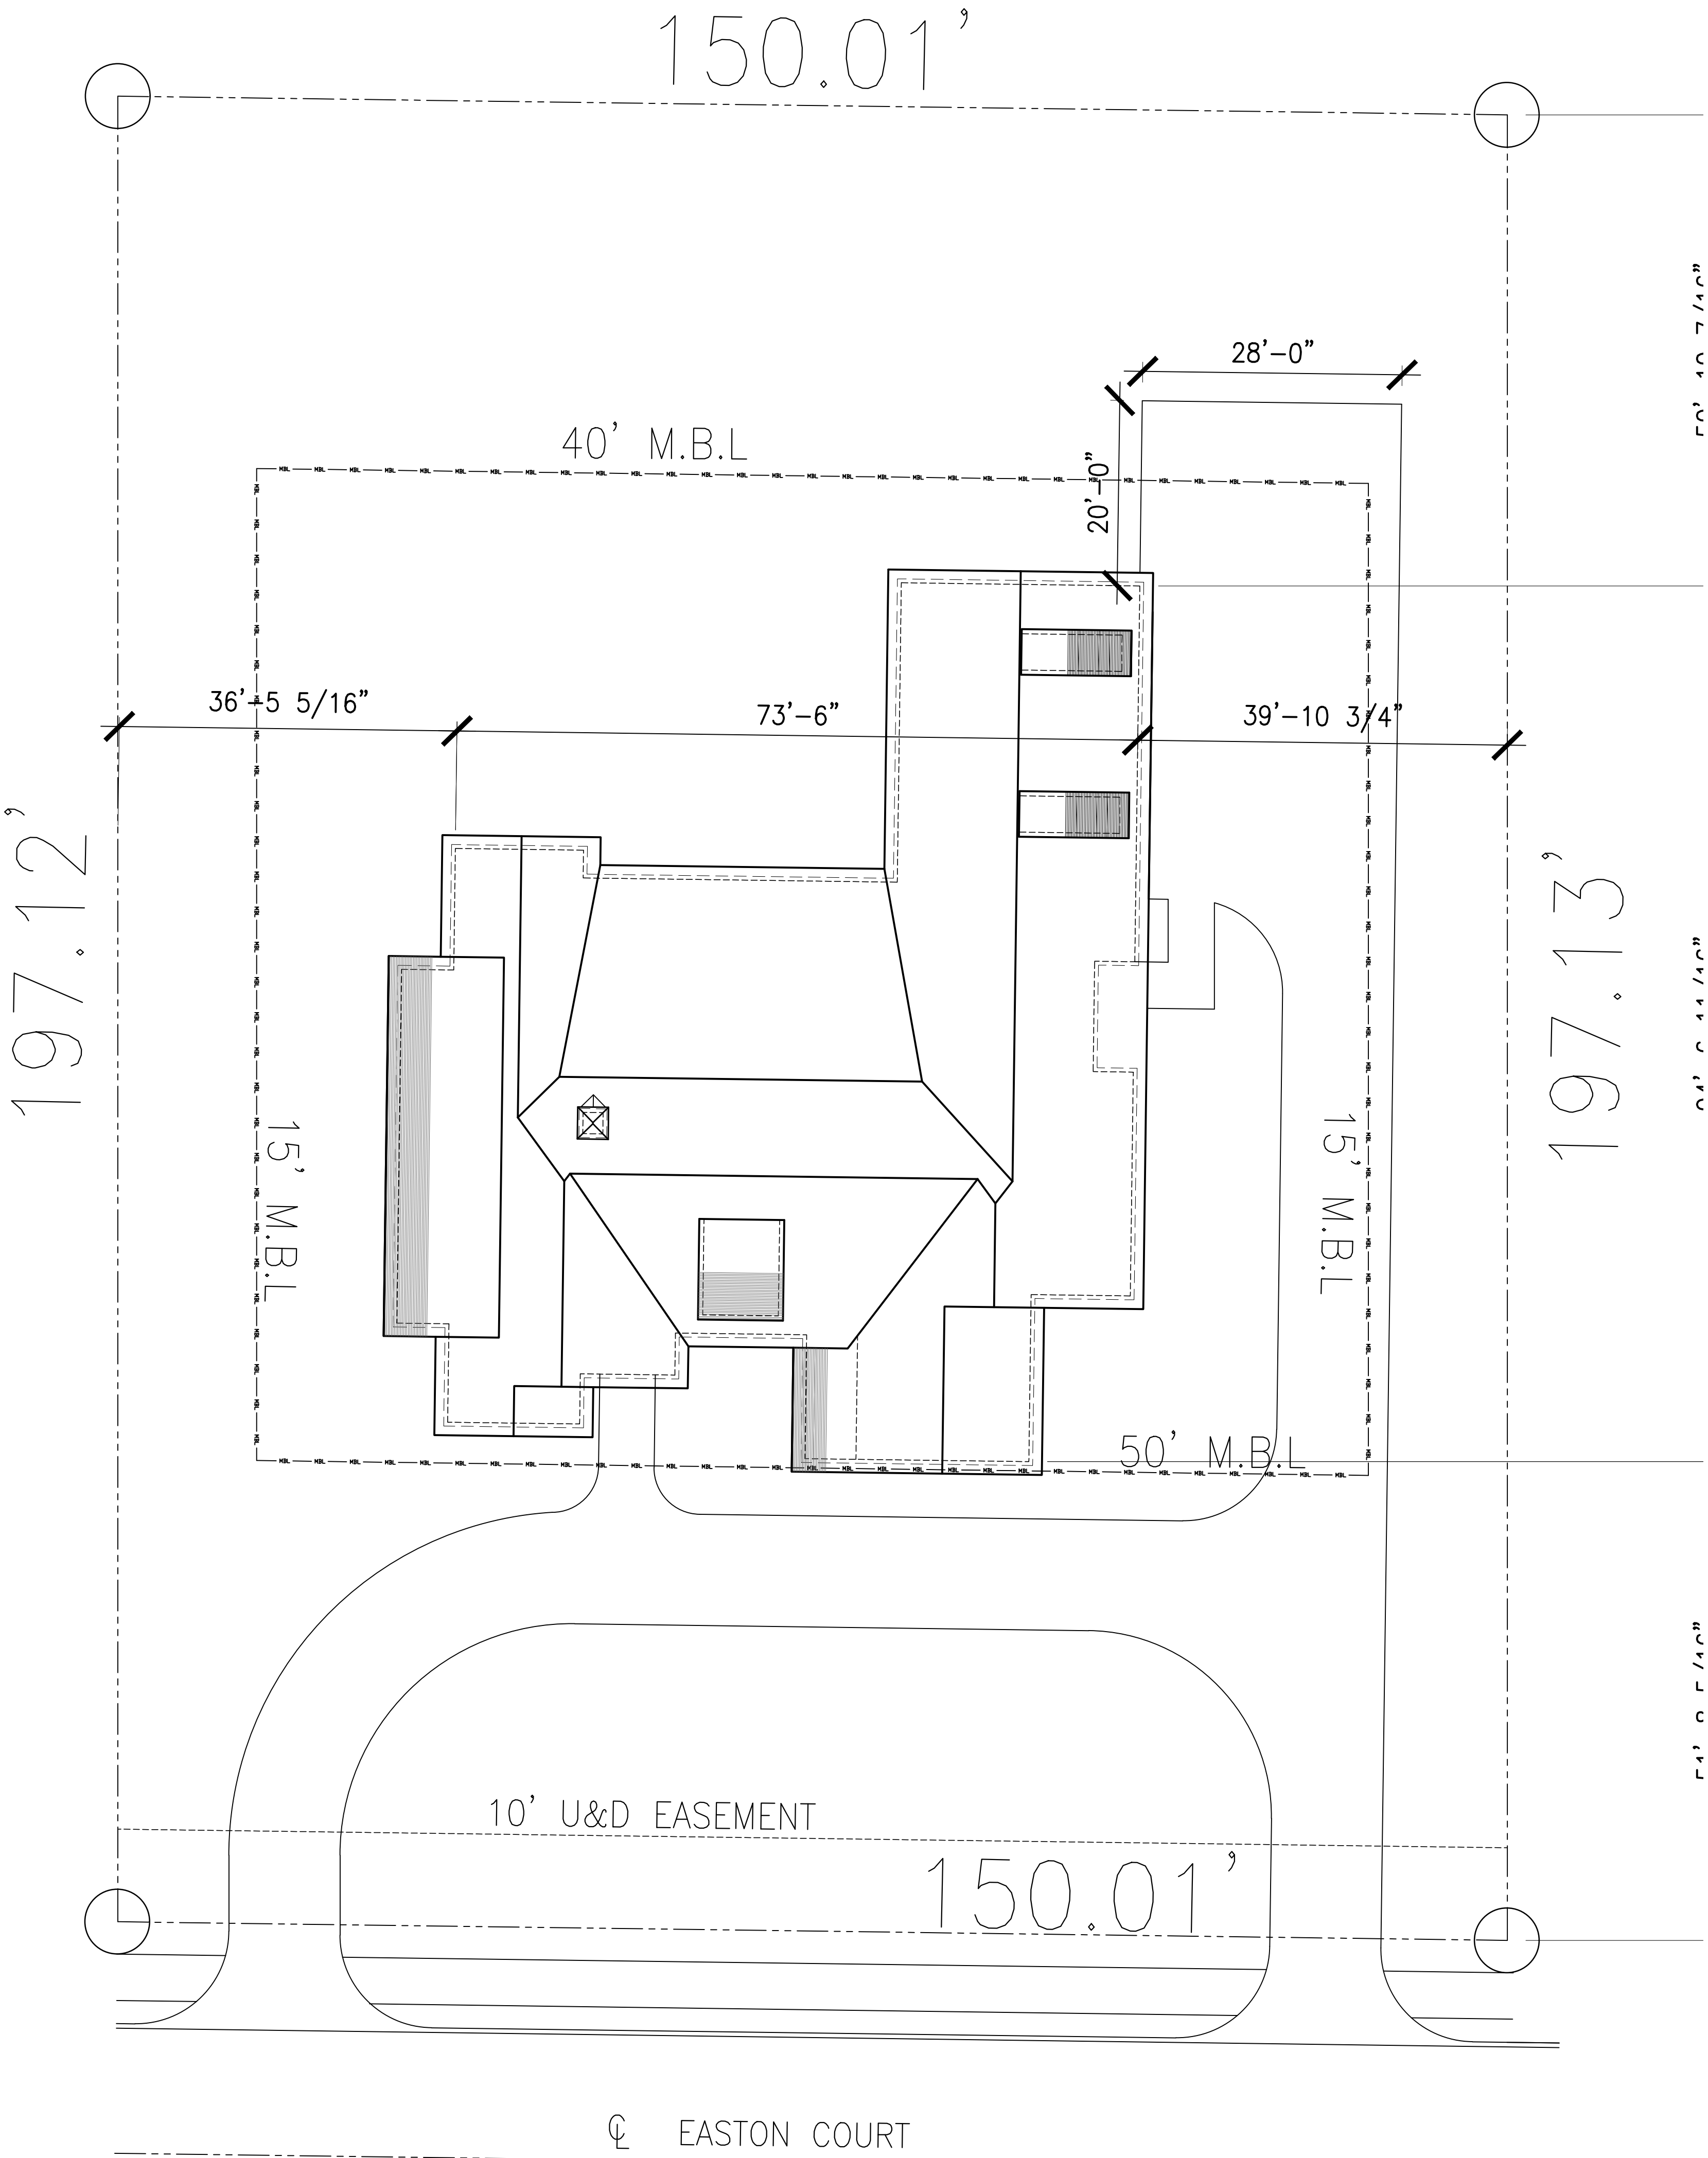

1 SITE PLAN
A-1.100 SCALE: 3/32" = 1'-0"

REVISION LOG:		
NO.	DATE	REMARKS

DRAWN/CHECKED BY:

TC

SITE PLAN
FOR
249 EASTON COURT
A NEW RESIDENCE IN
DOTHAN, ALABAMA



R&S CONSTRUCTION
REEVES AND SHAW CONSTRUCTION
Professional Consulting Engineers and Construction Services

JOB NUMBER:


DATE:

February 26

SHEET TITLE & NO.

SITE PLAN

A-1.100

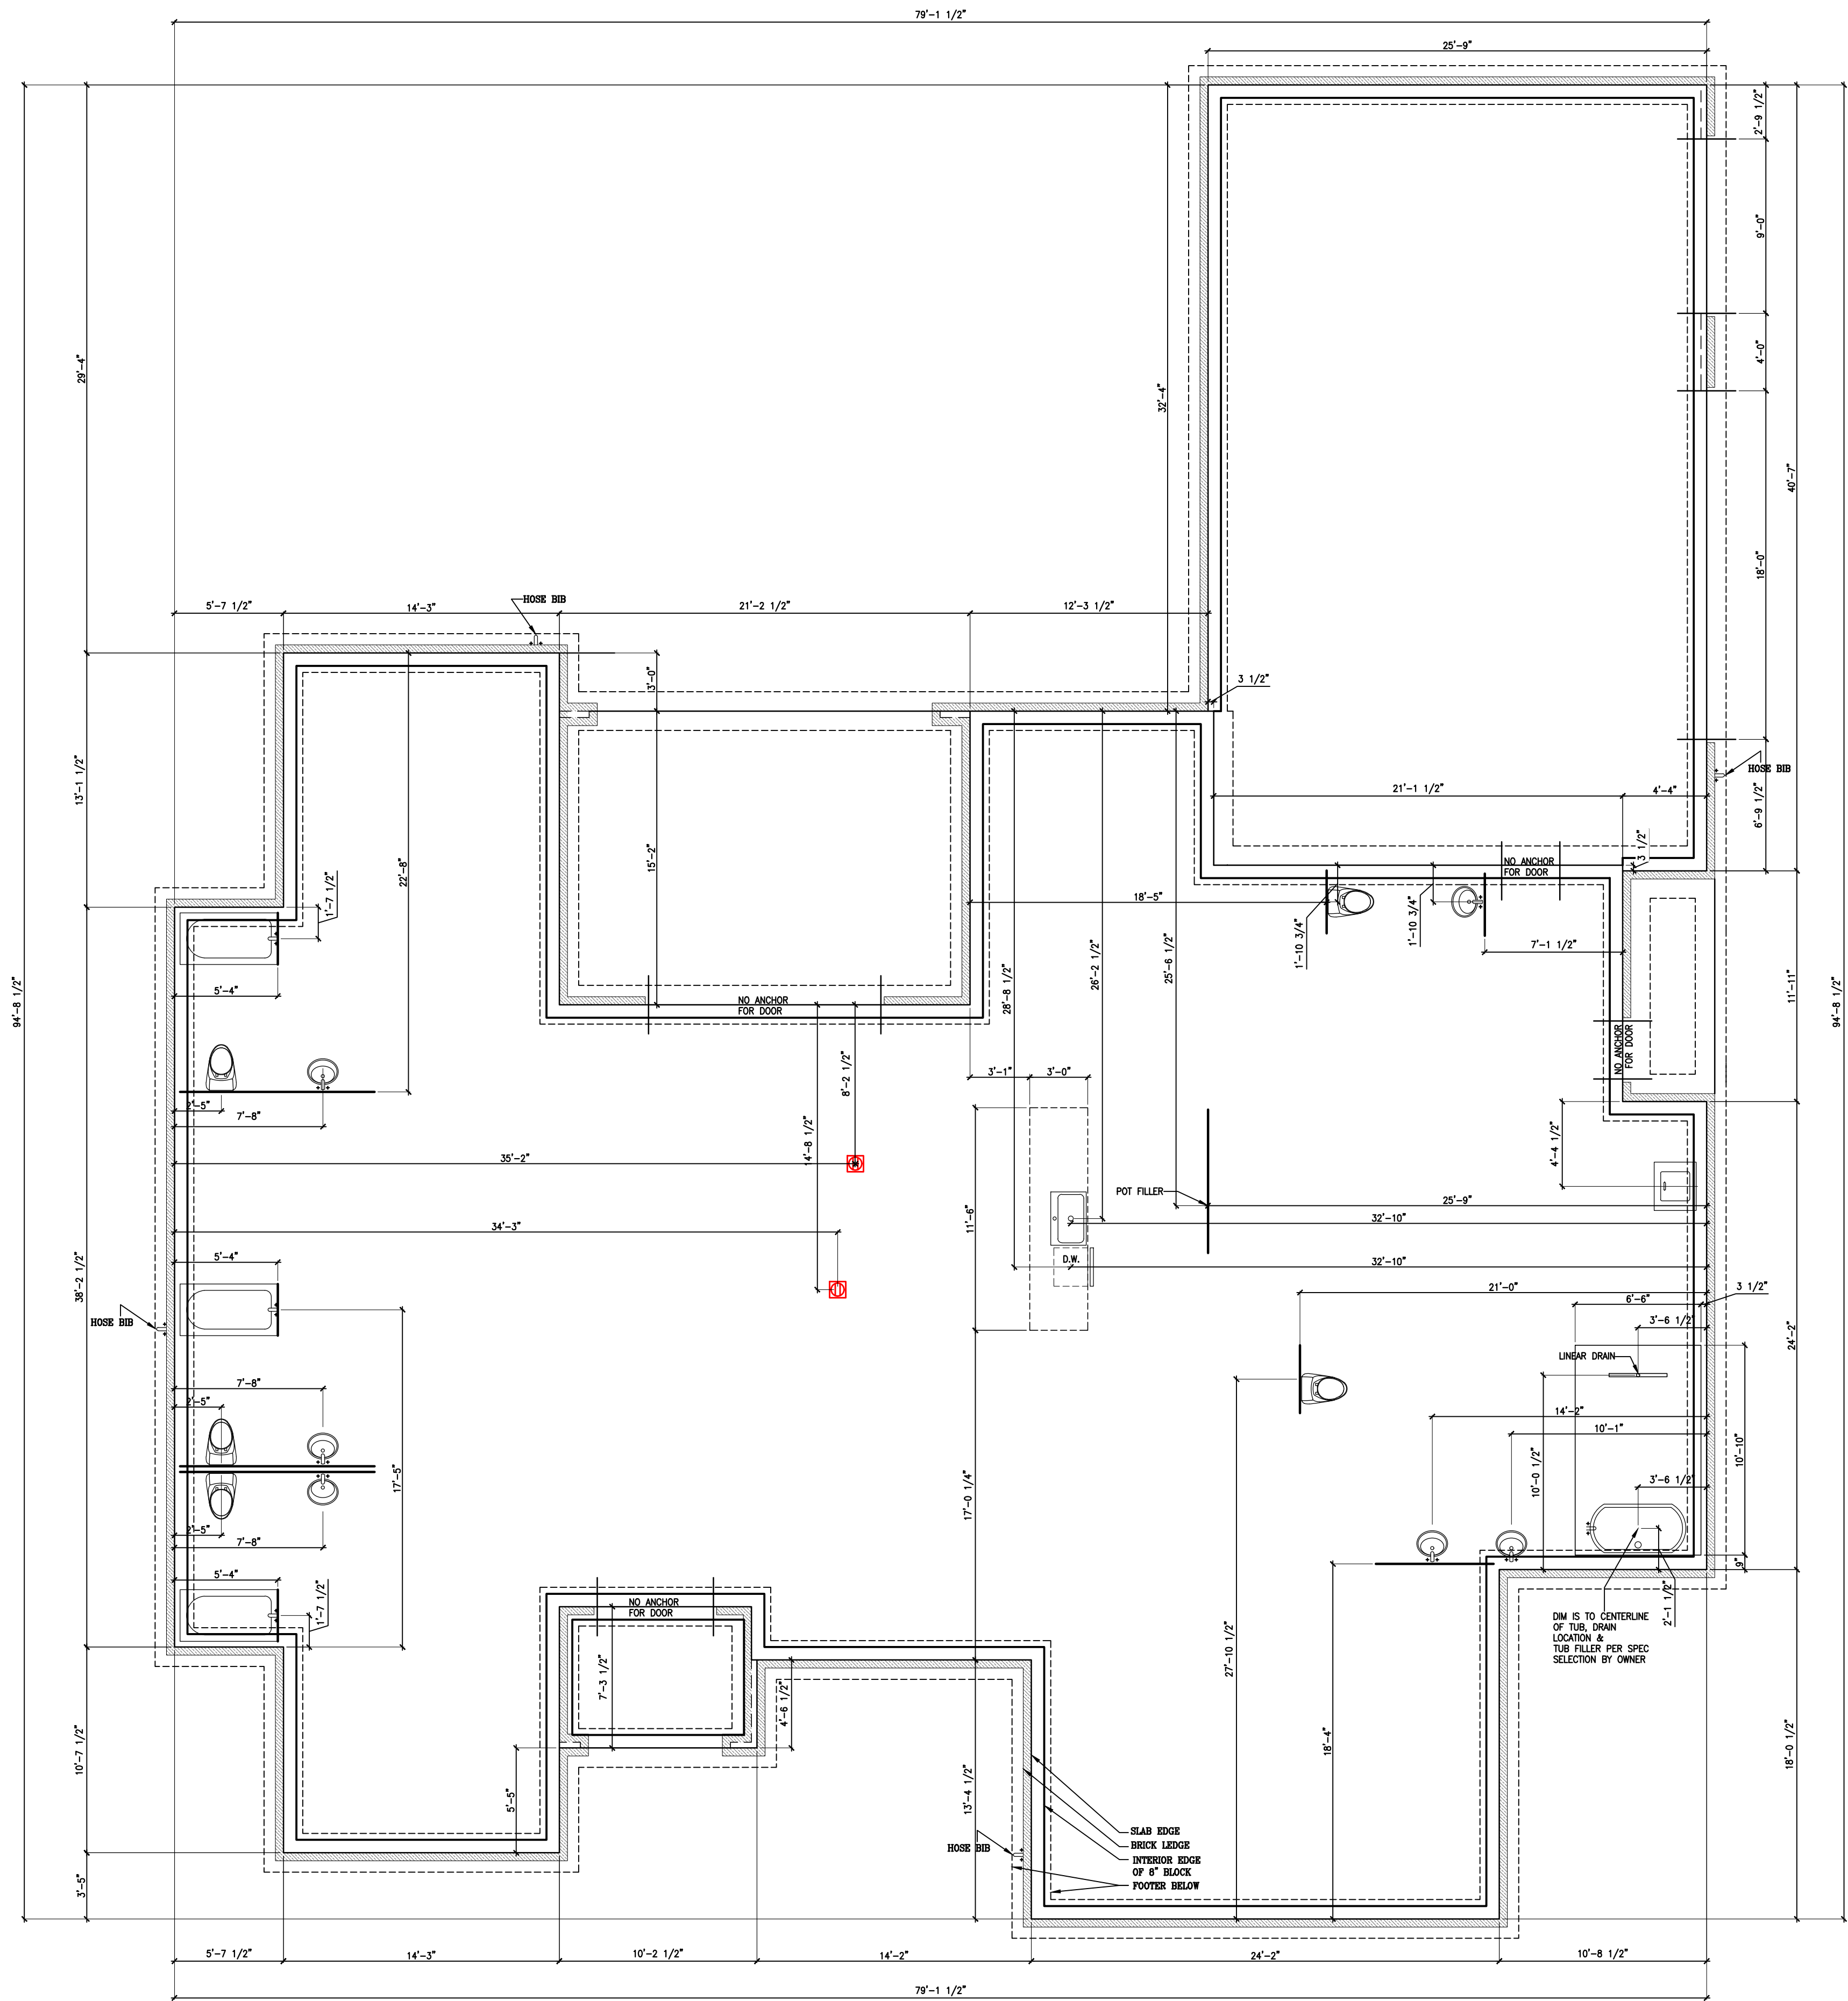

1 FOUNDATION PLAN
A-2.000 SCALE: 3/16\" = 1'-0"

REVISION LOG:

NO.	DATE	REMARKS

DRAWN/CHECKED BY:

TC

FOUNDATION PLAN
FOR
249 EASTON COURT
A NEW RESIDENCE IN
DOTHAN, ALABAMA



R&S CONSTRUCTION


REEVES AND SHAW CONSTRUCTION
Professional Consulting Engineers and Construction Services
3680 West Main Street - Dothan, Alabama 36305 334.677.5600

JOB NUMBER:

DATE:
February 26

SHEET TITLE & NO.
FOUNDATION PLAN

A-2.000

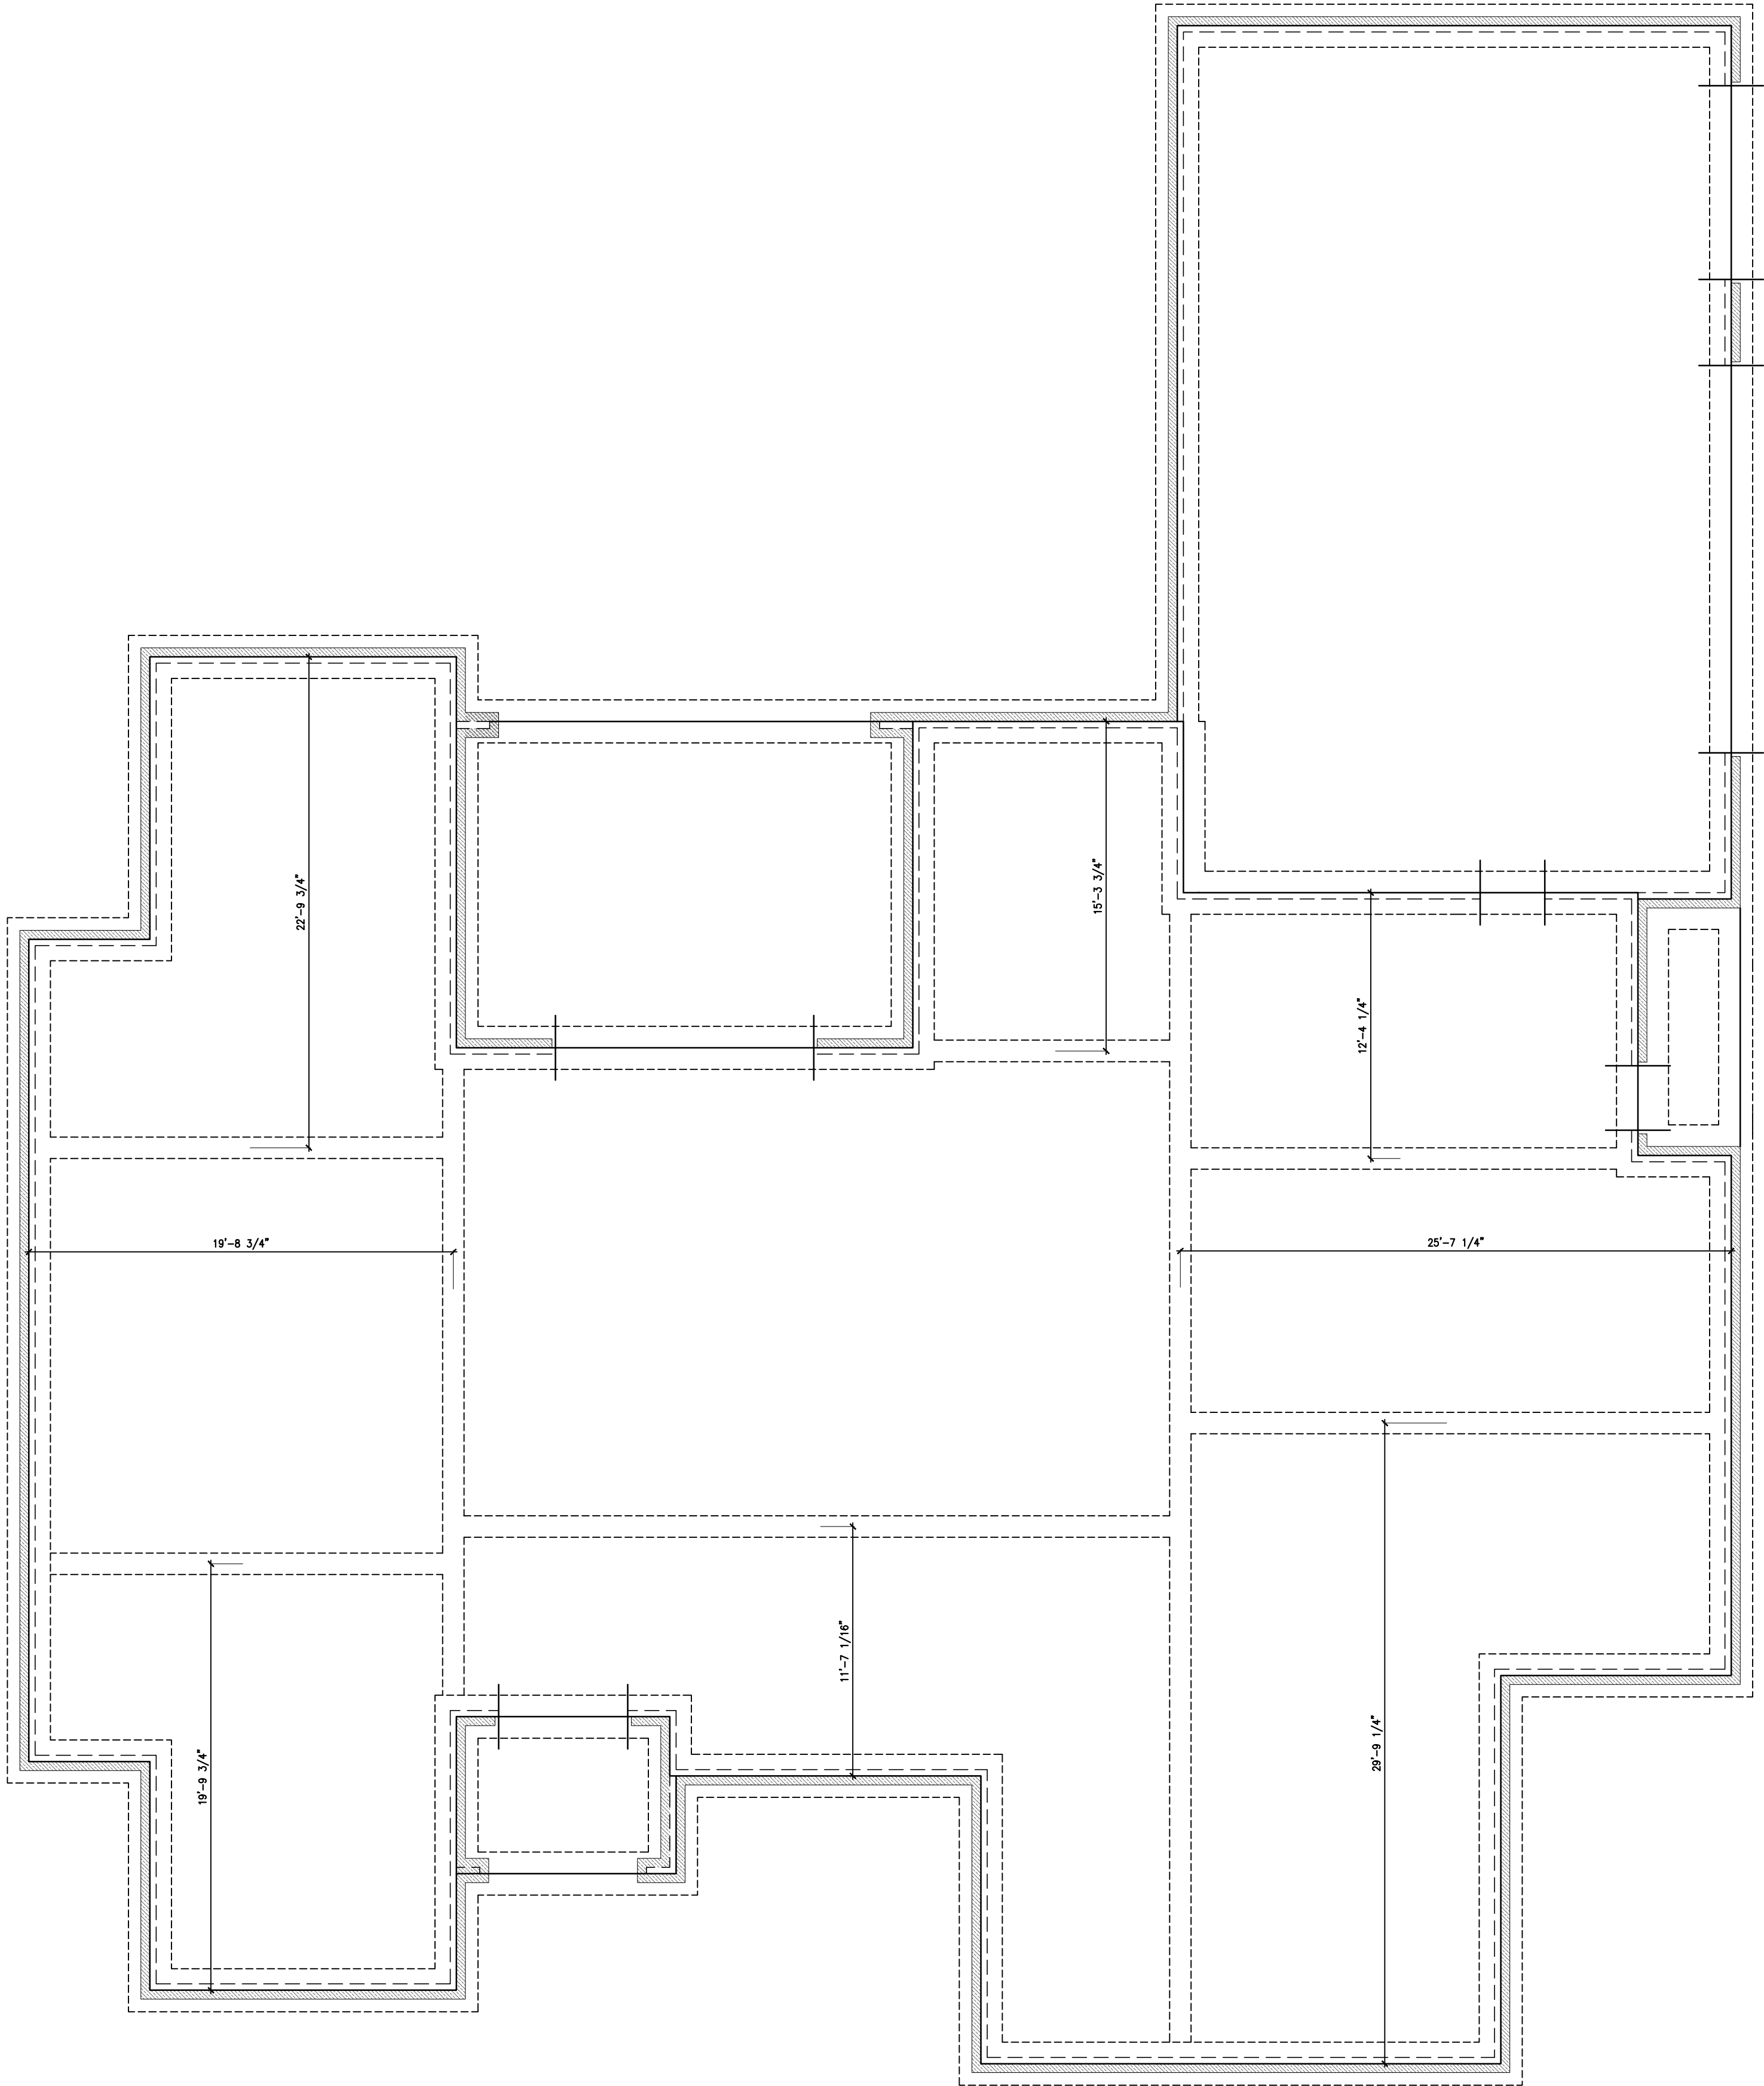

1
A-2.001

GRADE BEAM PLAN
SCALE: 3/16" = 1'-0"

REVISION LOG:

NO.	DATE	REMARKS

DRAWN/CHECKED BY:

TC

GRADE BEAM PLAN
FOR
249 EASTON COURT
A NEW RESIDENCE IN
DOTHAN, ALABAMA



R&S CONSTRUCTION
REEVES AND SHAW CONSTRUCTION
Professional Consulting Engineers and Construction Services
3680 West Main Street - Dothan, Alabama 36305 334.677.5600

JOB NUMBER:

DATE:

February 26

SHEET TITLE & NO.

GRADE BEAM PLAN

A-2.001


WALL LEGEND	
	2x4 STUD WALLS
	2x6 STUD WALLS
	BRICK VENEER

HEATED SQUARE FOOTAGE	
BASE PLAN:	
MAIN LEVEL	3,676 S.F.
UPPER LEVEL	681 S.F.
TOTAL	4,357 S.F.

UNHEATED SQUARE FOOTAGE	
MAIN LEVEL:	
3-CAR GARAGE	1044 S.F.
REAR PORCH	309 S.F.
FRONT PORCH	63 S.F.
TOTAL:	1,416 S.F.

SCHEDULE TAGS	
	WINDOW
	CASED OPENING
	EXTERIOR DOOR
	INTERIOR DOOR

LIFE SAFETY LEGEND	
	EGRESS WINDOW - 5.66 SF CLEAR AREA 24" MIN. HGT. CLEAR 20" MIN. WIDTH CLEAR 44" MAX. SILL HEIGHT ABV. F.F.
	TEMPERED GLASS

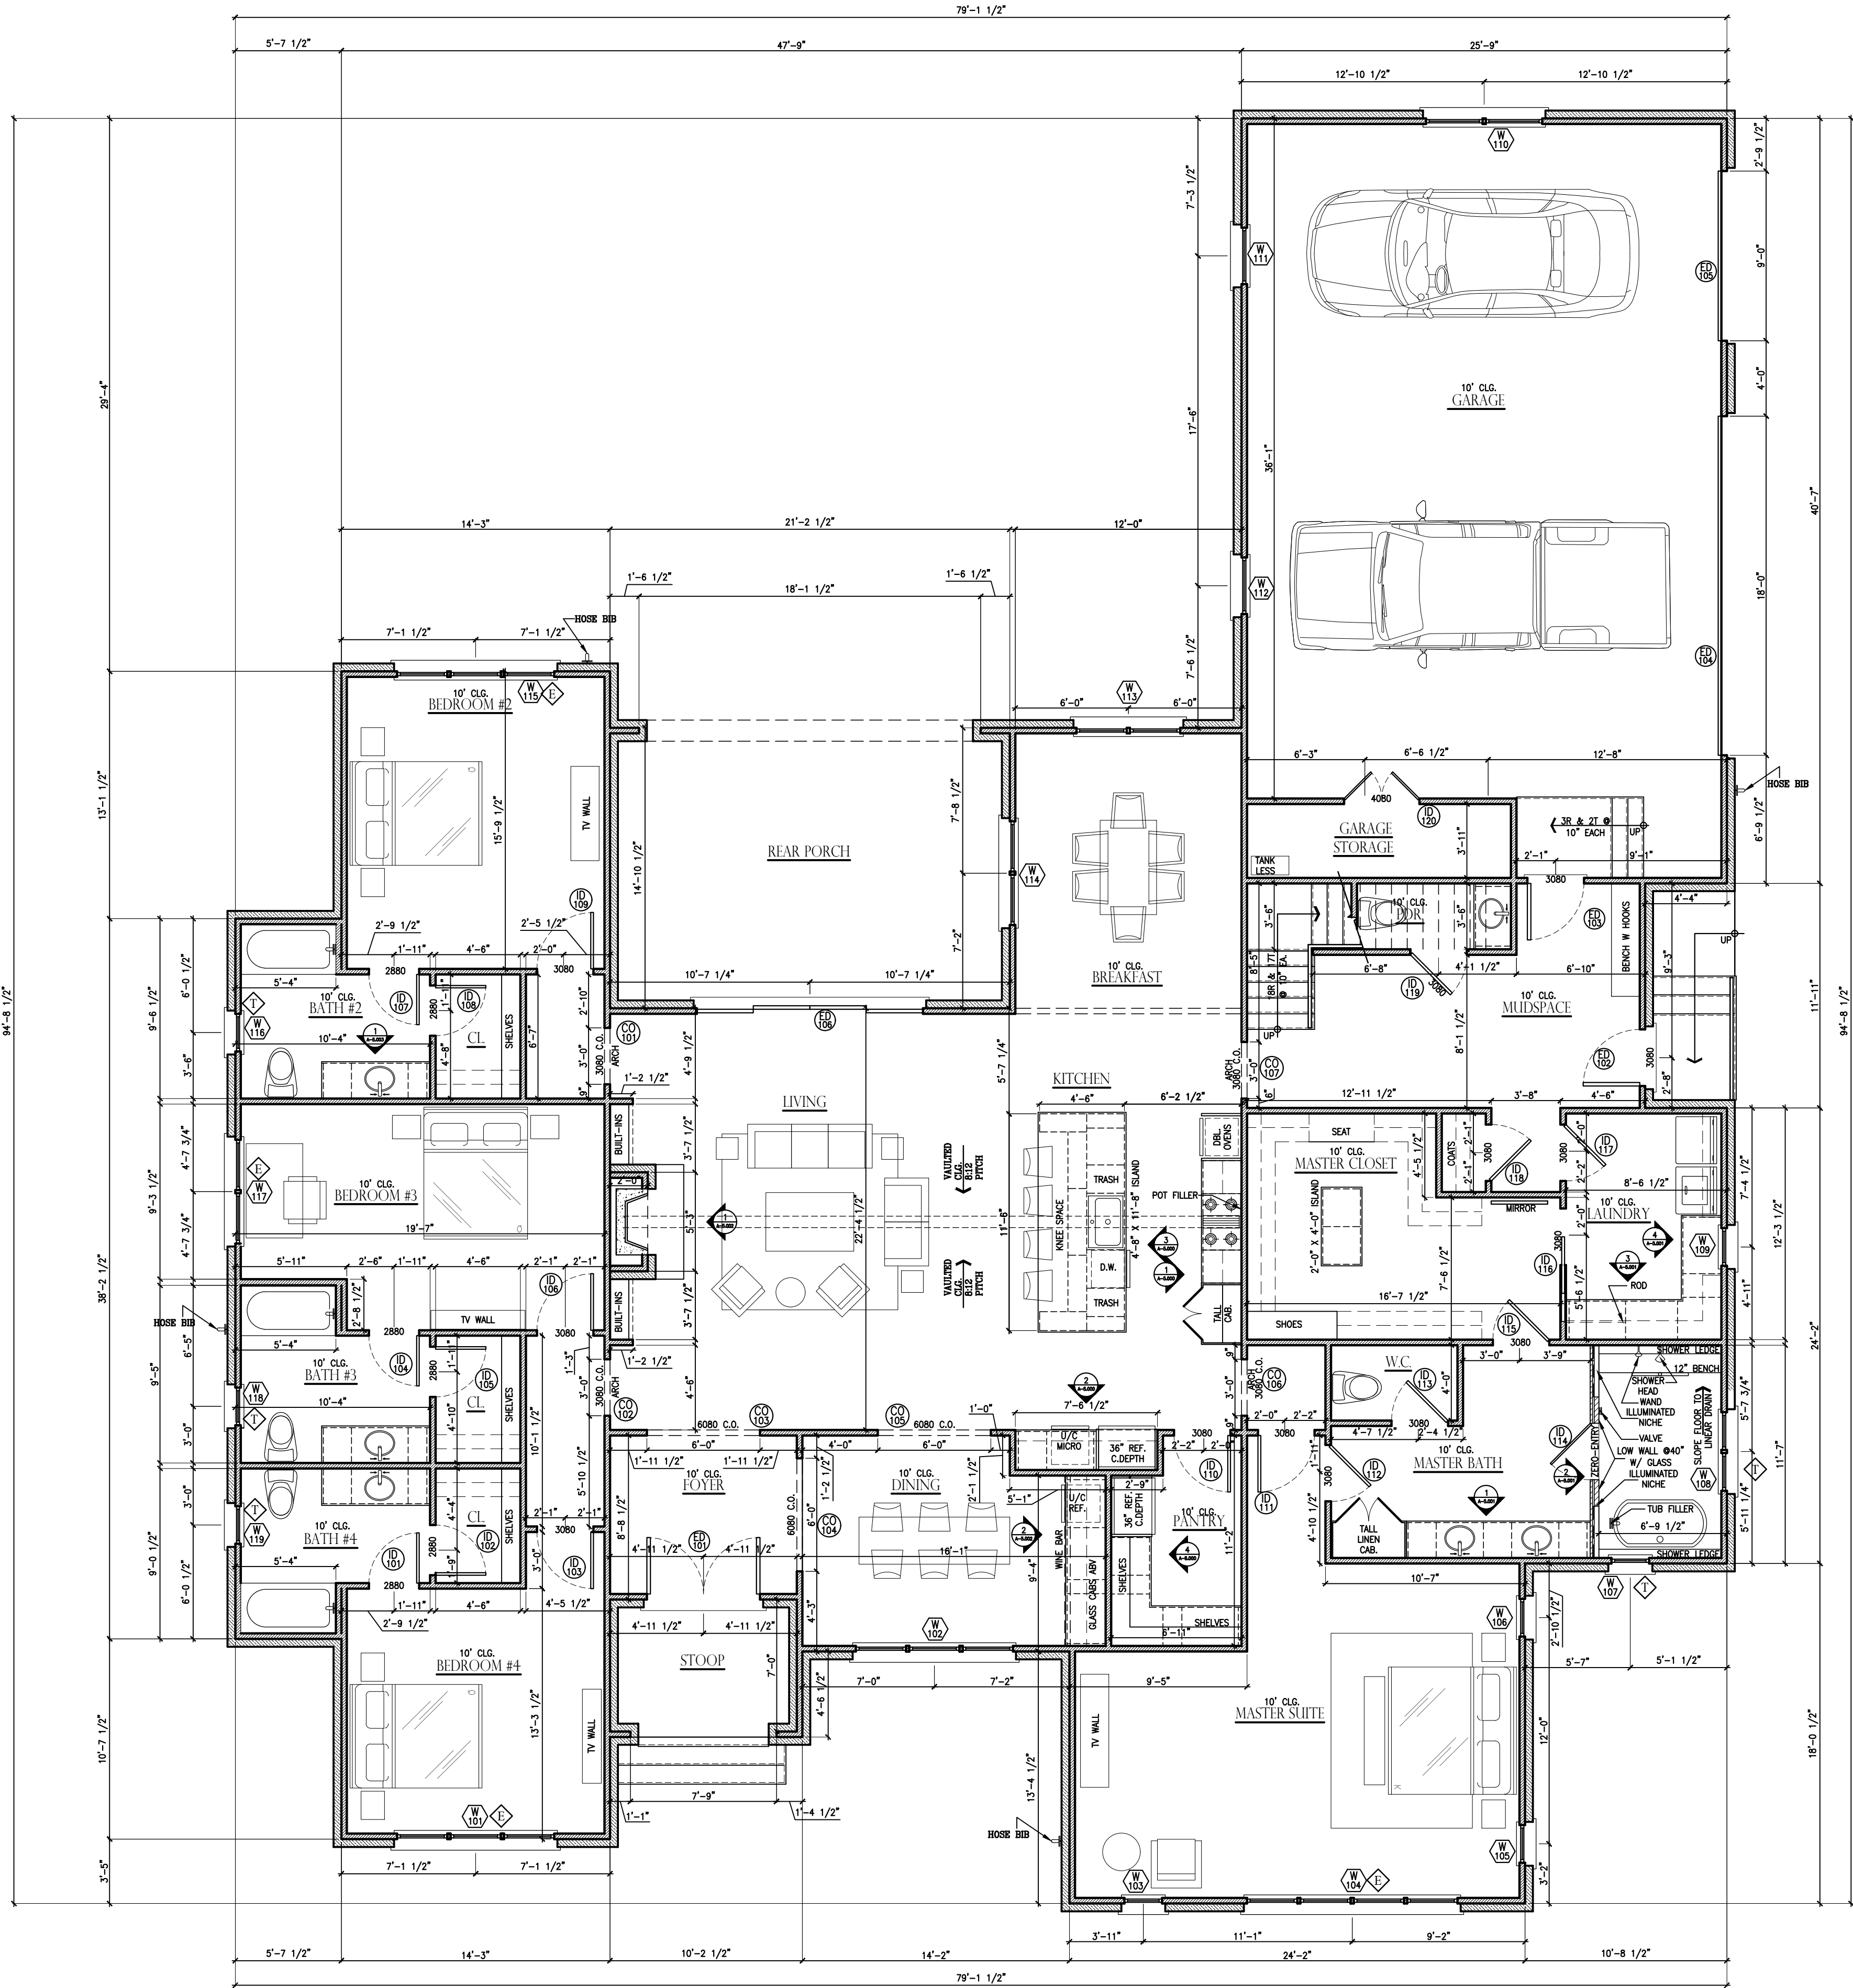

1
A-2.010 MAIN LEVEL FLOOR PLAN
SCALE: 3/16" = 1'-0"

REVISION LOG:

NO. DATE REMARKS

DRAWN/CHECKED BY:

TC

MAIN LEVEL FLOOR PLAN
FOR
249 EASTON COURT
A NEW RESIDENCE IN
DOTHAN, ALABAMA



R&S CONSTRUCTION
REEVES AND SHAW CONSTRUCTION
Professional Consulting Engineers and Construction Services
3680 West Main Street - Dothan, Alabama 36605 334.677.5600

JOB NUMBER:

DATE:

February 26

SHEET TITLE & NO.

MAIN LEVEL FLOOR PLAN

A-2.010



WALL LEGEND	
	2x4 STUD WALLS
	2x6 STUD WALLS
	BRICK VENEER

HEATED SQUARE FOOTAGE	
BASE PLAN:	
MAIN LEVEL	3,676 S.F.
UPPER LEVEL	681 S.F.
TOTAL	4,357 S.F.

UNHEATED SQUARE FOOTAGE	
MAIN LEVEL:	
3-CAR GARAGE	1044 S.F.
REAR PORCH	309 S.F.
FRONT PORCH	63 S.F.
TOTAL:	1,416 S.F.

SCHEDULE TAGS	
	WINDOW
	CASED OPENING
	EXTERIOR DOOR
	INTERIOR DOOR

LIFE SAFETY LEGEND	
	EGRESS WINDOW - 5.66 SF CLEAR AREA 24" MIN. HGT. CLEAR 20" MIN. WIDTH CLEAR 44" MAX. SILL HEIGHT ABV. F.F.
	TEMPERED GLASS

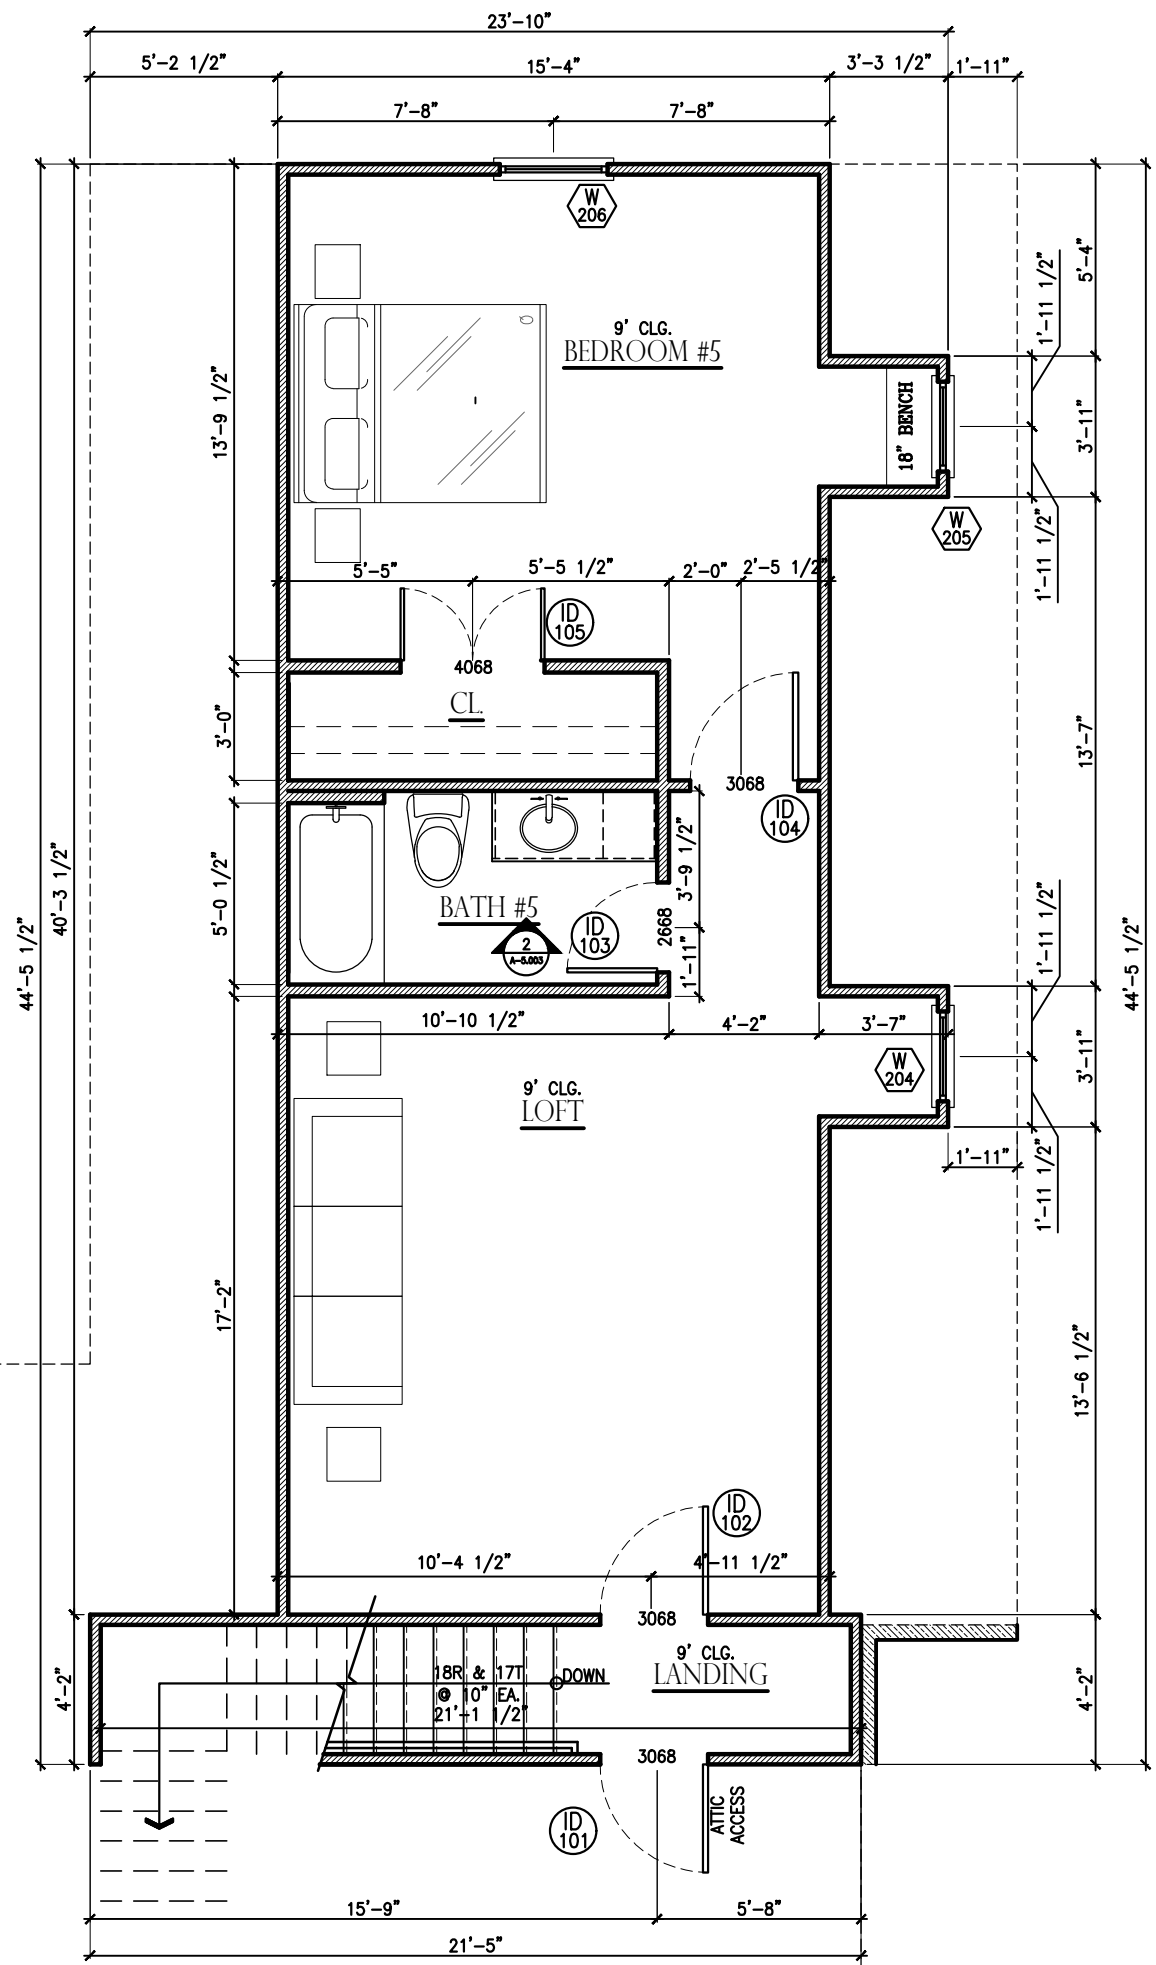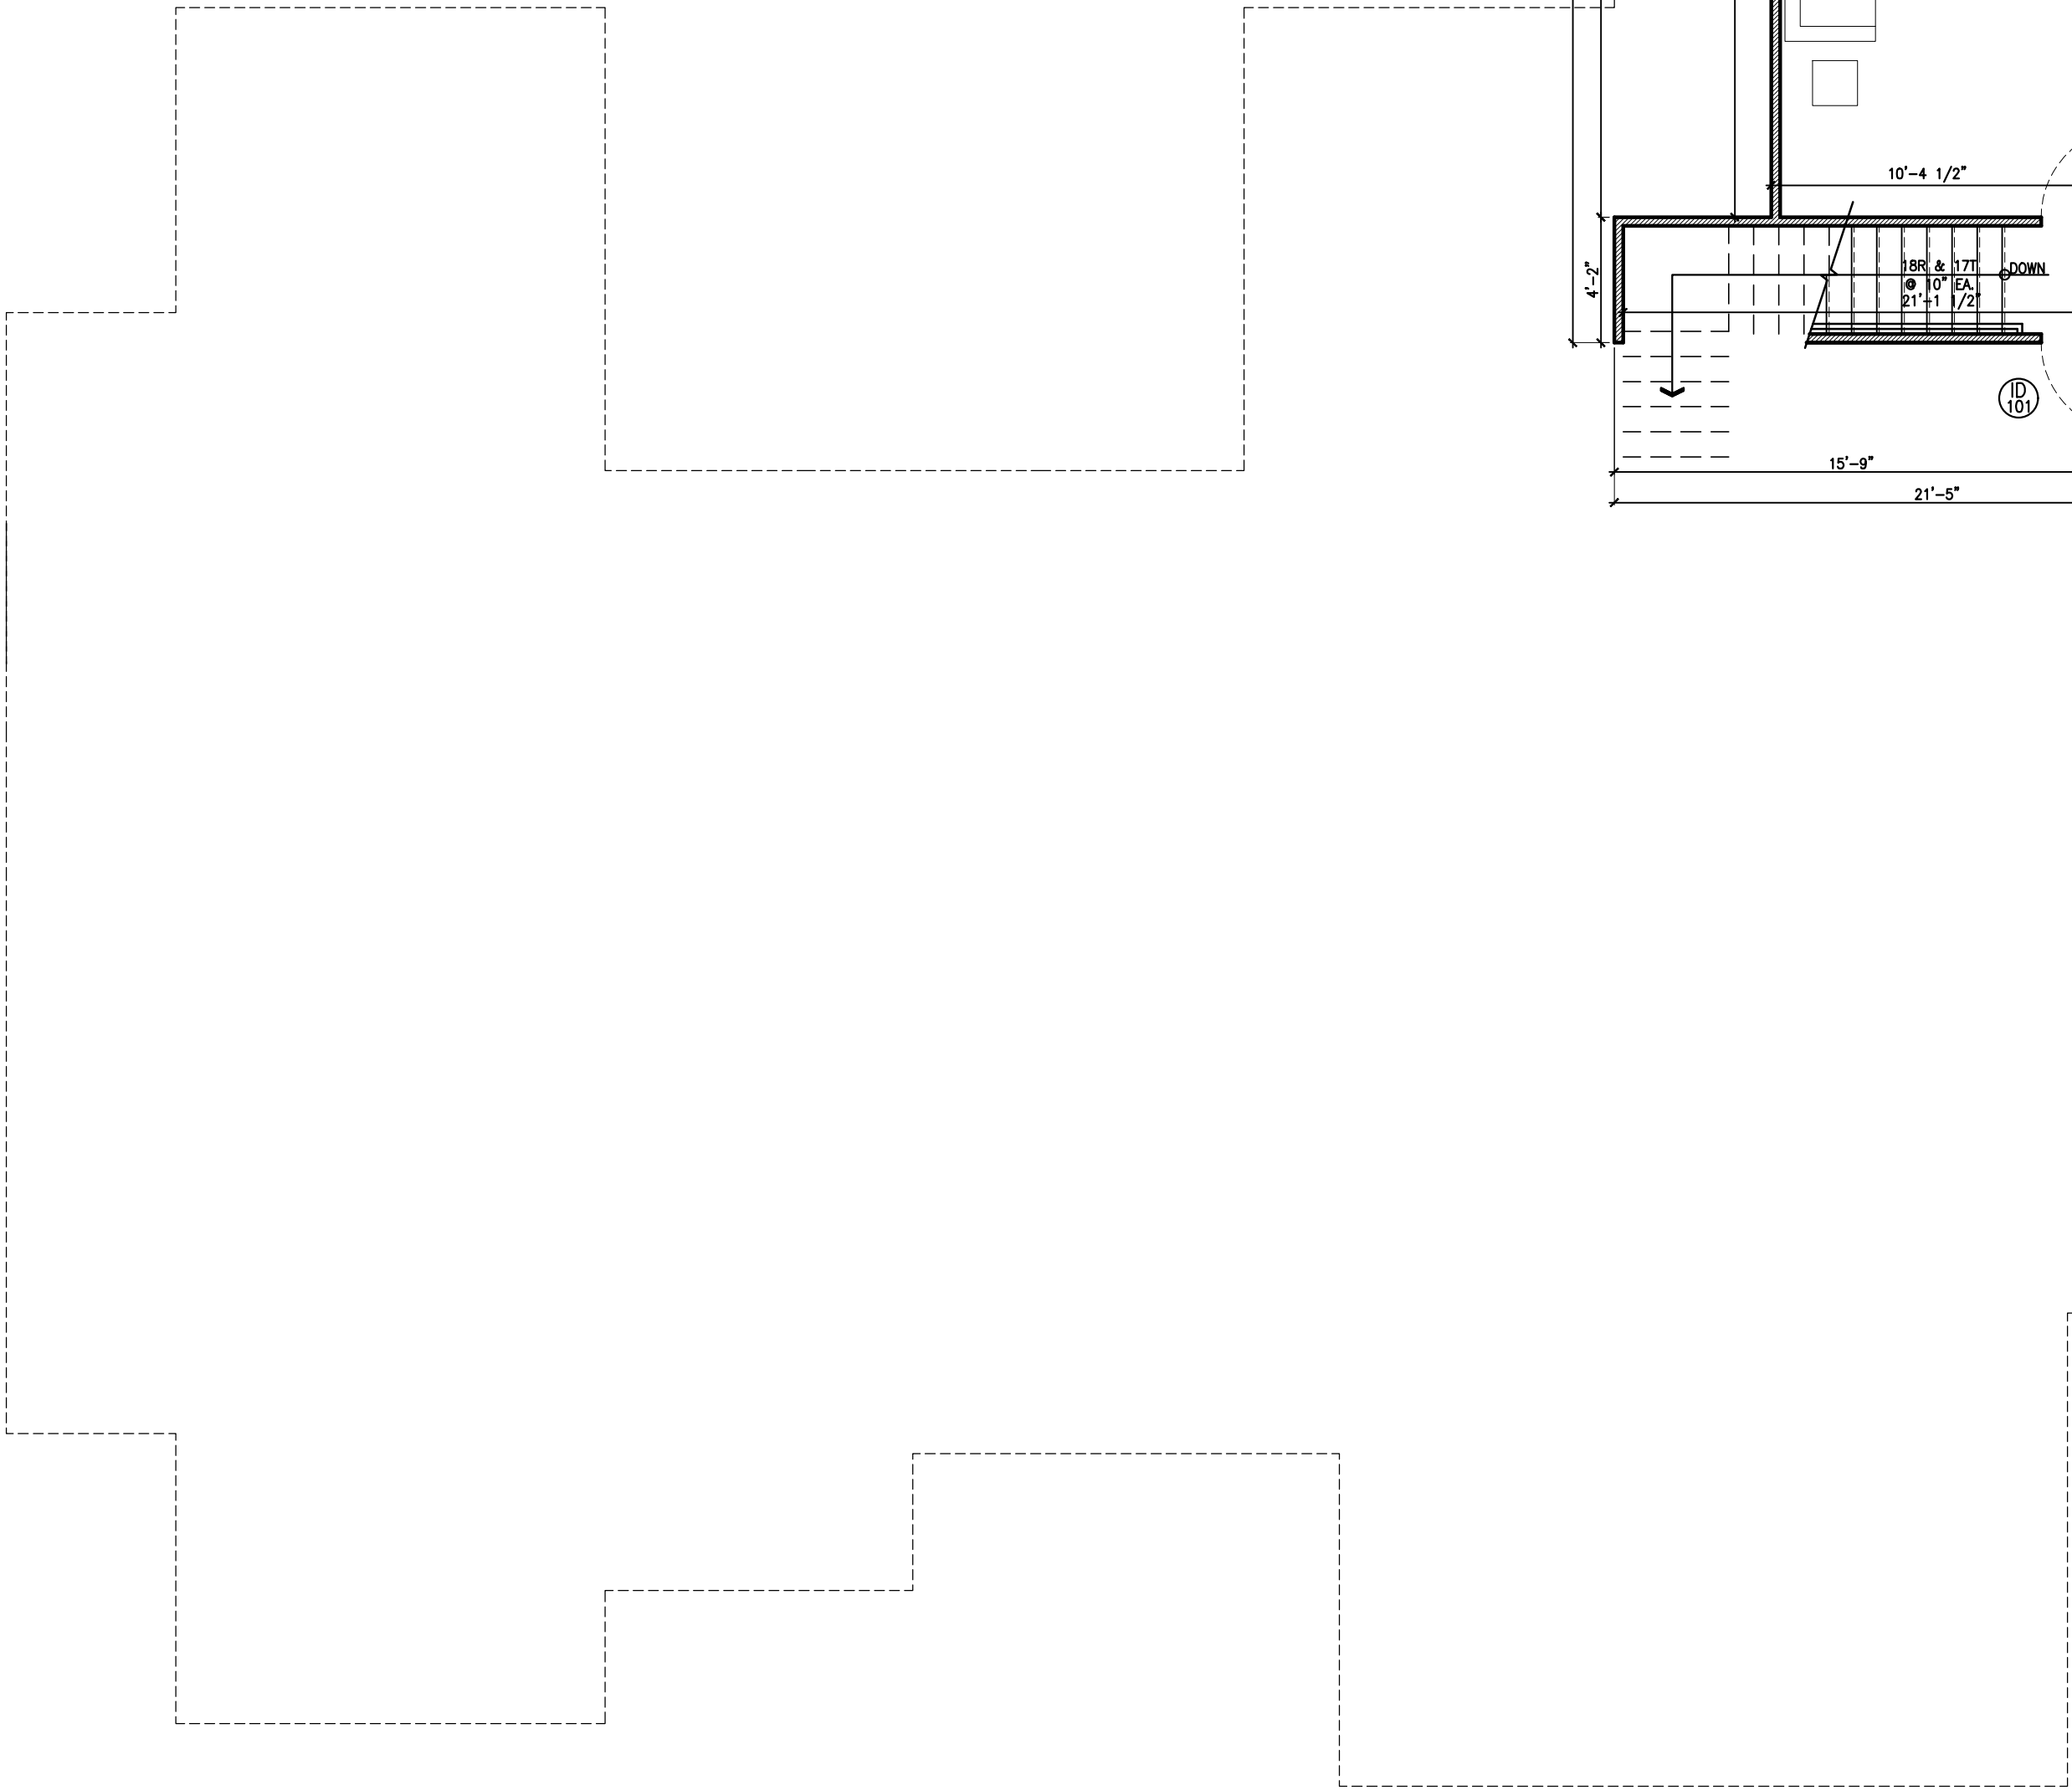

REVISION LOG:

NO.	DATE	REMARKS

DRAWN/CHECKED BY:

TC

UPPER LEVEL FLOOR PLAN
FOR
249 EASTON COURT
A NEW RESIDENCE IN
DOTHAN, ALABAMA


REEVES & SHAW
CONSTRUCTION

R&S CONSTRUCTION

REEVES AND SHAW CONSTRUCTION

Professional Consulting Engineers and Construction Services
3680 West Main Street - Dothan, Alabama 36305 334.677.5600

JOB NUMBER:


DATE:

February 26

SHEET TITLE & NO.

UPPER LEVEL FLOOR PLAN

A-2.020

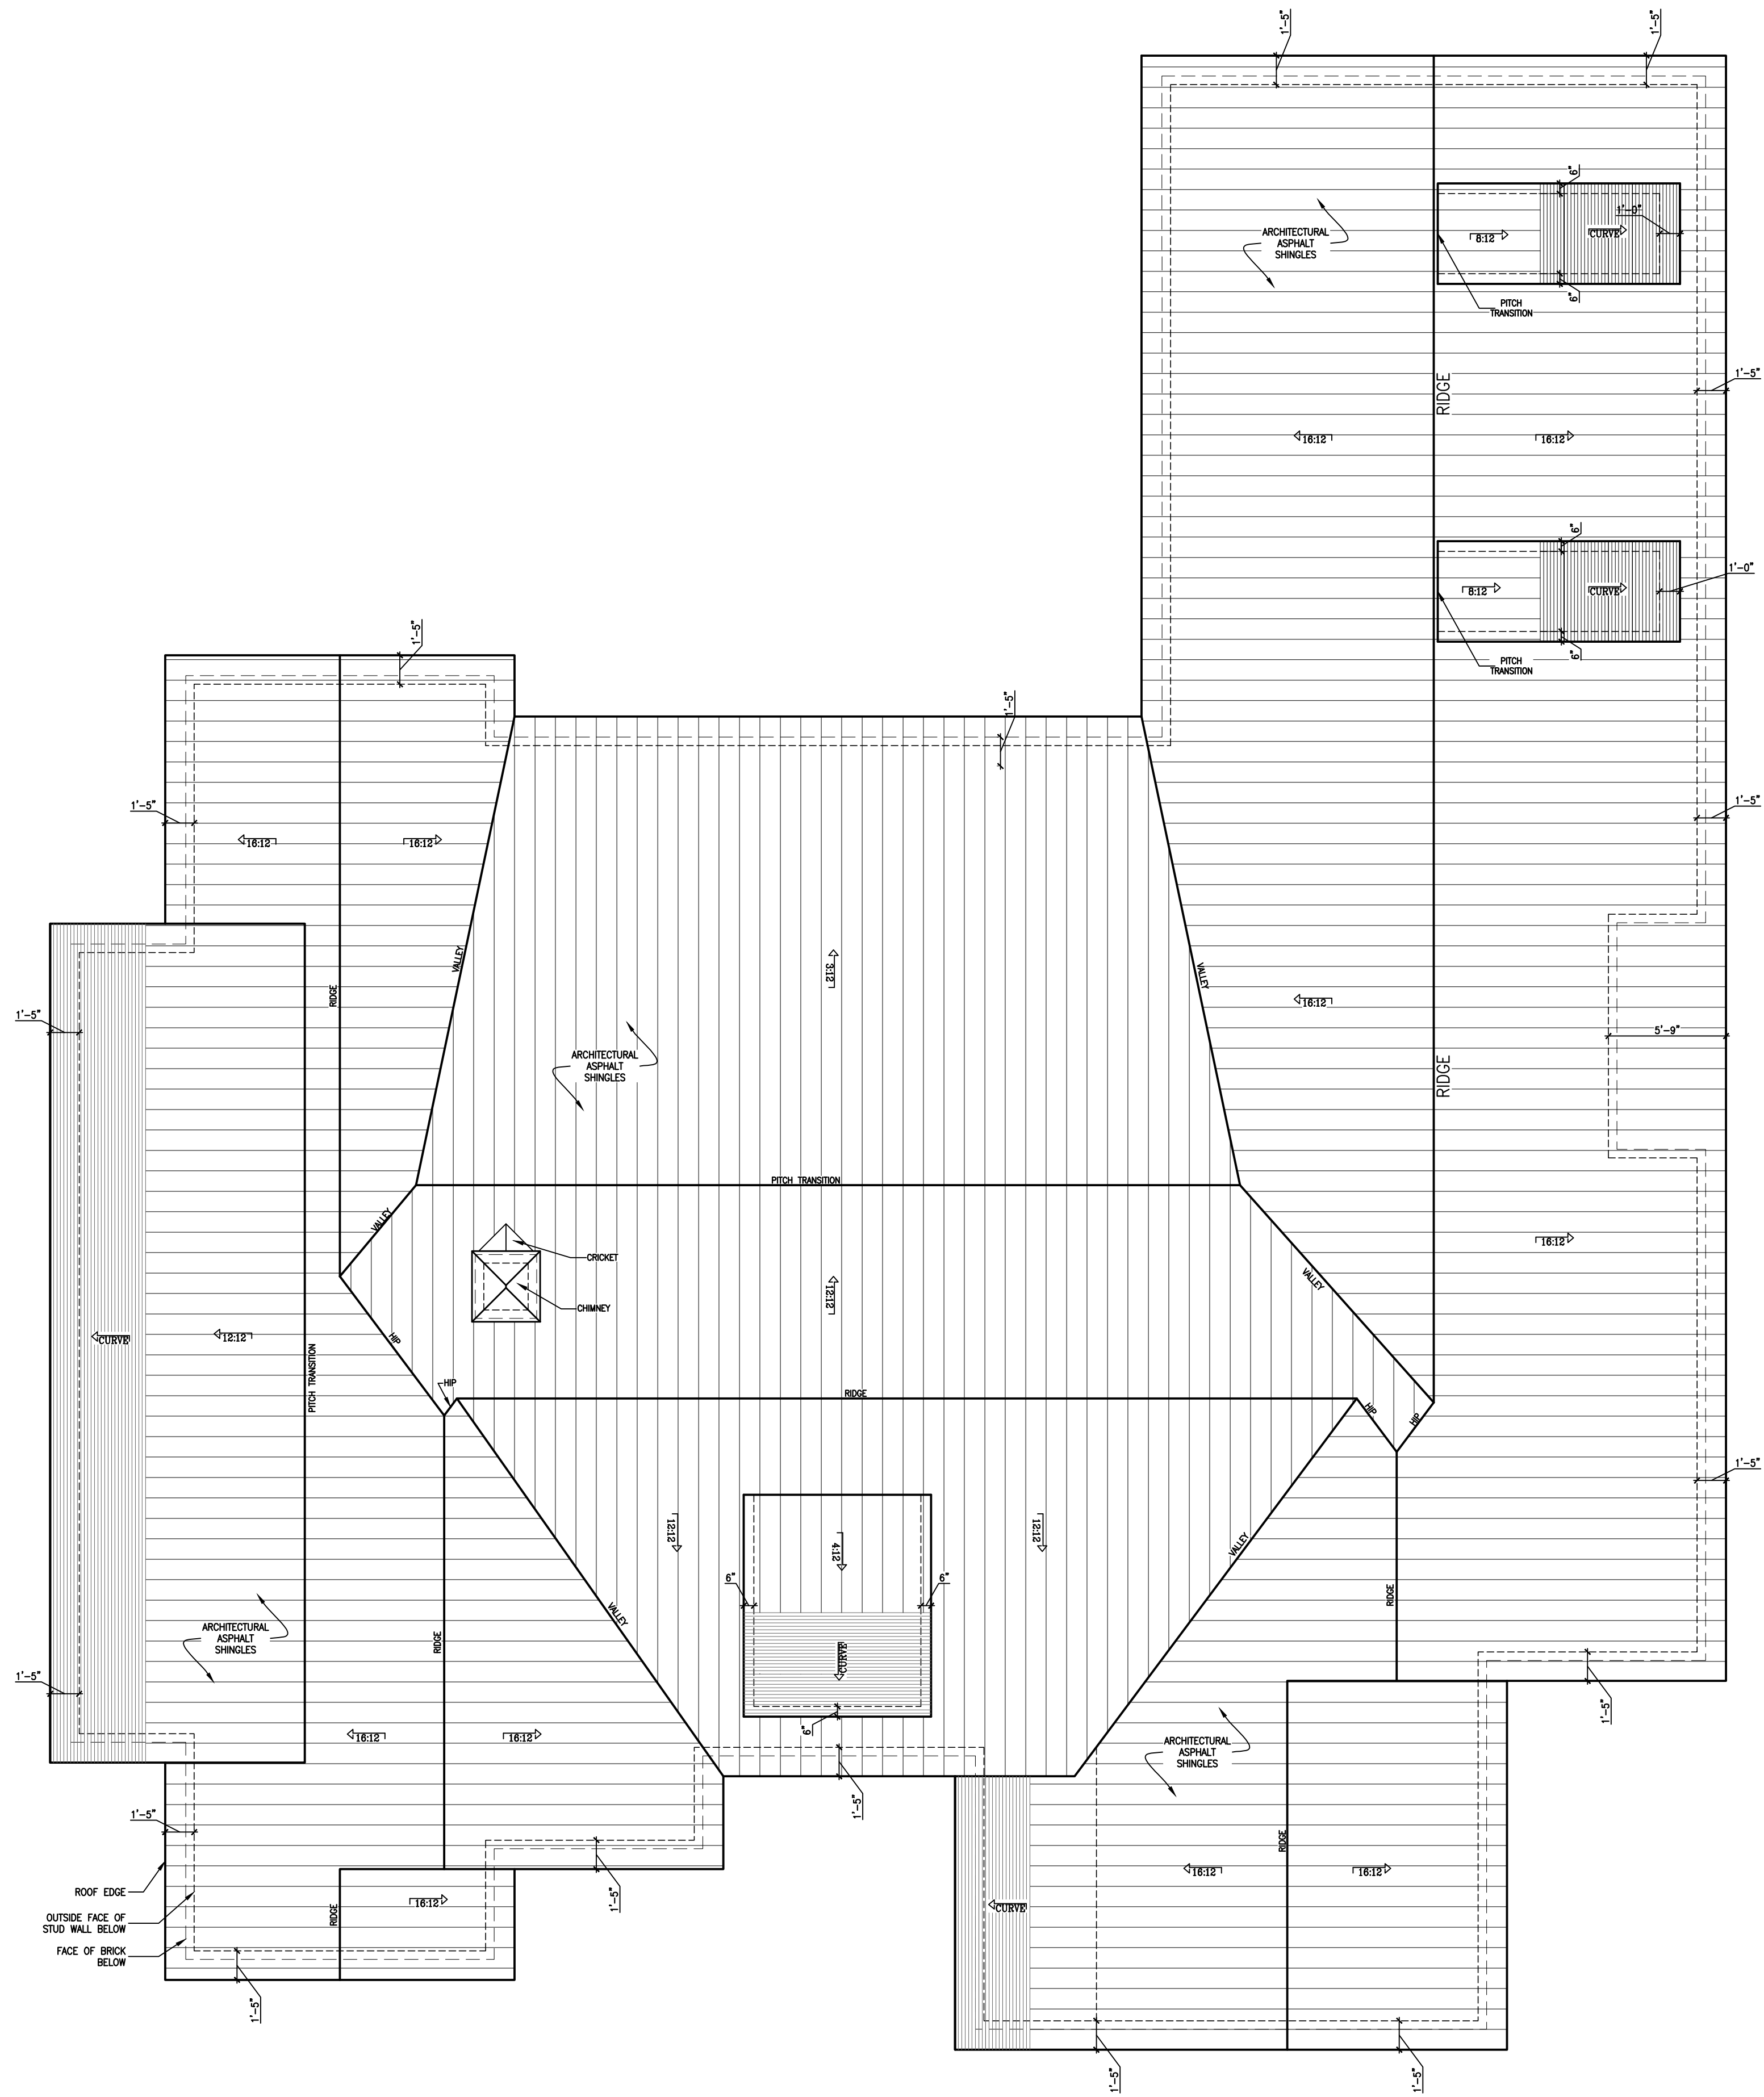

1 ROOF PLAN
A-2.100 SCALE: 3/16" = 1'-0"

REVISION LOG:

NO.	DATE	REMARKS

DRAWN/CHECKED BY:

TC

ROOF PLAN
FOR
249 EASTON COURT
A NEW RESIDENCE IN
DOTHAN, ALABAMA



REEVES & SHAW
CONSTRUCTION

R&S CONSTRUCTION

REEVES AND SHAW CONSTRUCTION
Professional Consulting Engineers and Construction Services
3680 West Main Street - Dothan, Alabama 36305 334.677.5600

JOB NUMBER:


DATE:

February 26

SHEET TITLE & NO.

ROOF PLAN

A-2.100

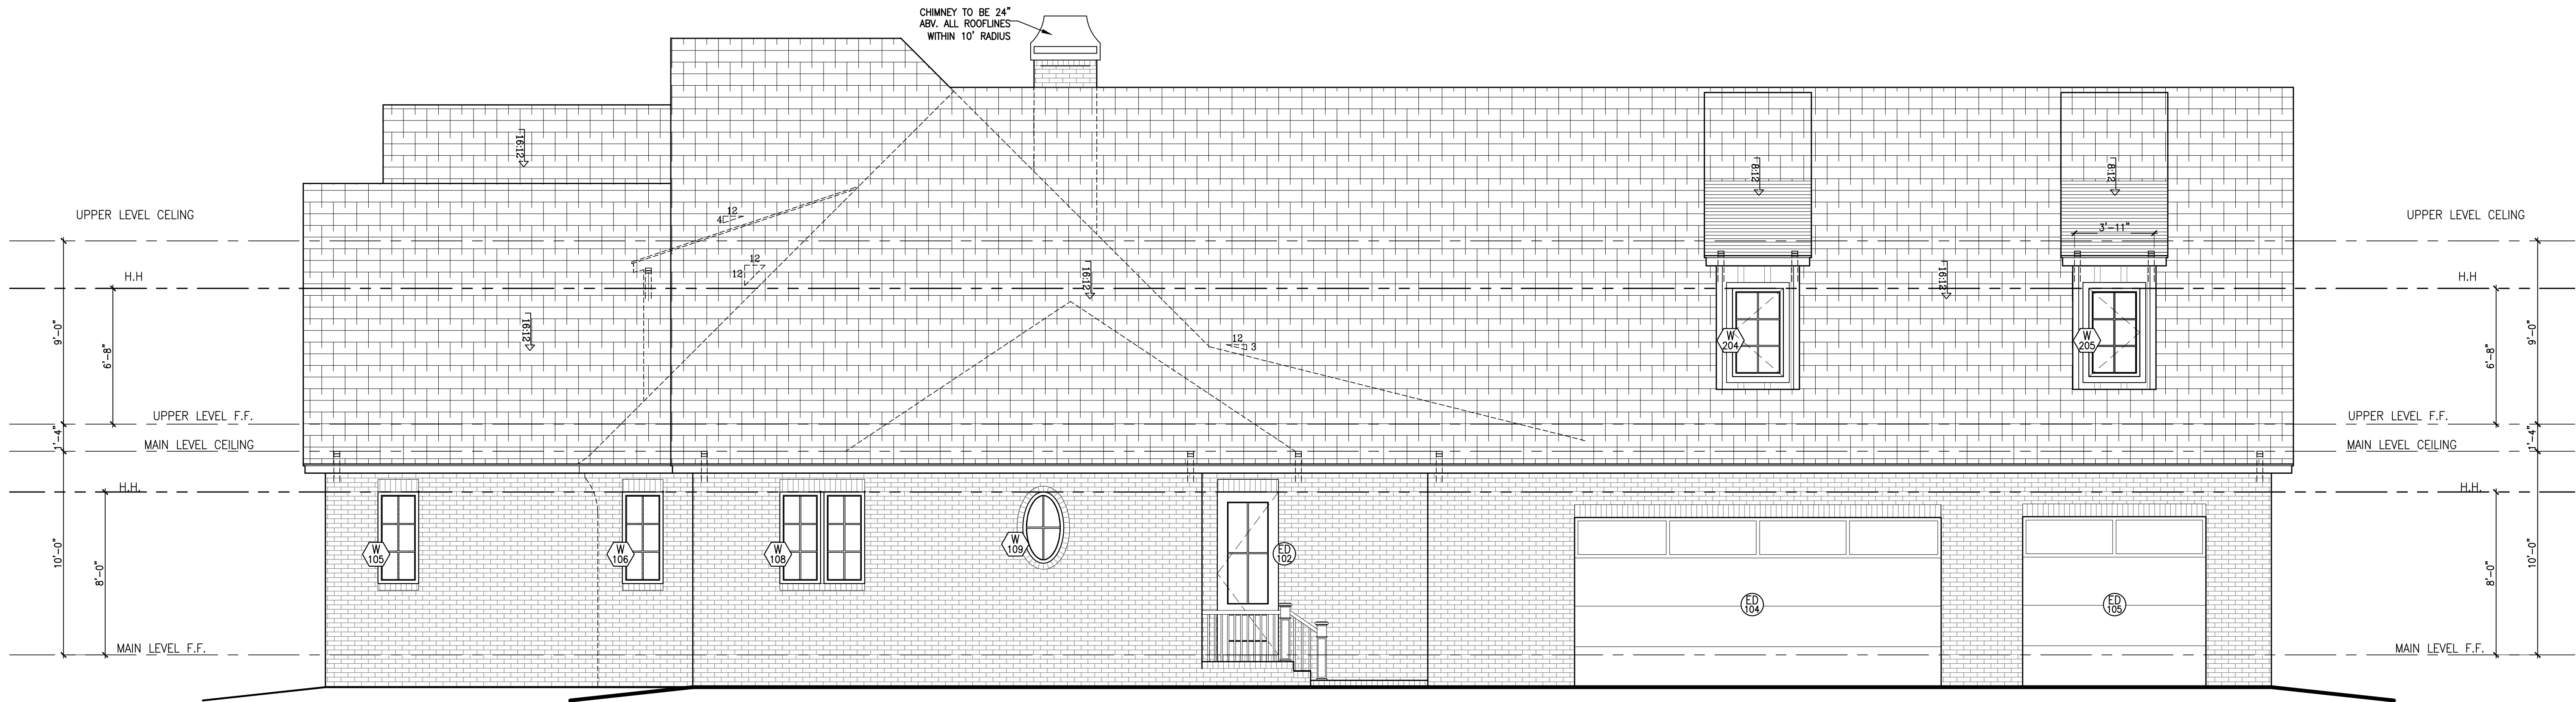

2 RIGHT ELEVATION
A-3.000 SCALE: 1/4" = 1'-0"



1 FRONT ELEVATION
A-3.000 SCALE: 1/4" = 1'-0"

REVISION LOG:

NO. DATE REMARKS

DRAWN/CHECKED BY:

TC

ELEVATIONS
FOR
249 EASTON COURT
A NEW RESIDENCE IN
DOTHAN, ALABAMA



REEVES & SHAW
CONSTRUCTION

R&S CONSTRUCTION

REEVES AND SHAW CONSTRUCTION

Professional Consulting Engineers and Construction Services
3680 West Main Street - Dothan, Alabama 36305 334.677.5600

JOB NUMBER:


DATE:

February 26


SHEET TITLE & NO.

ELEVATIONS

A-3.000

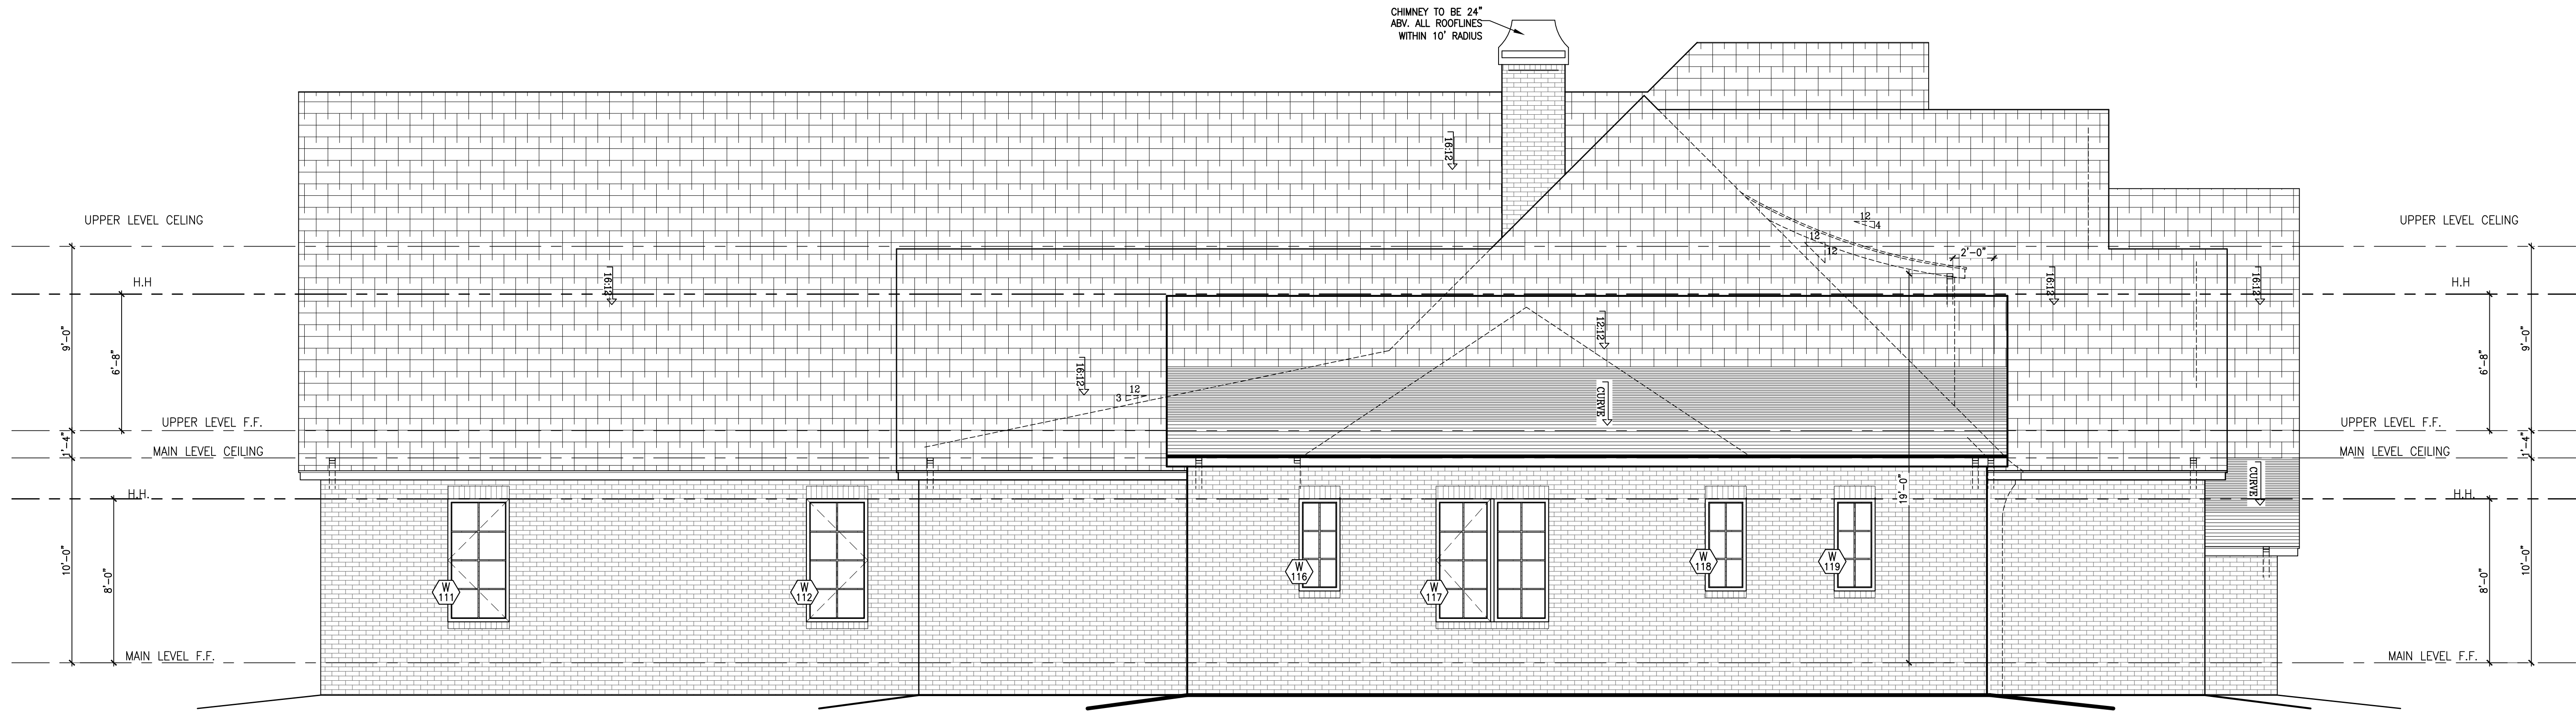

2 LEFT ELEVATION
A-3.001 SCALE: 1/4" = 1'-0"

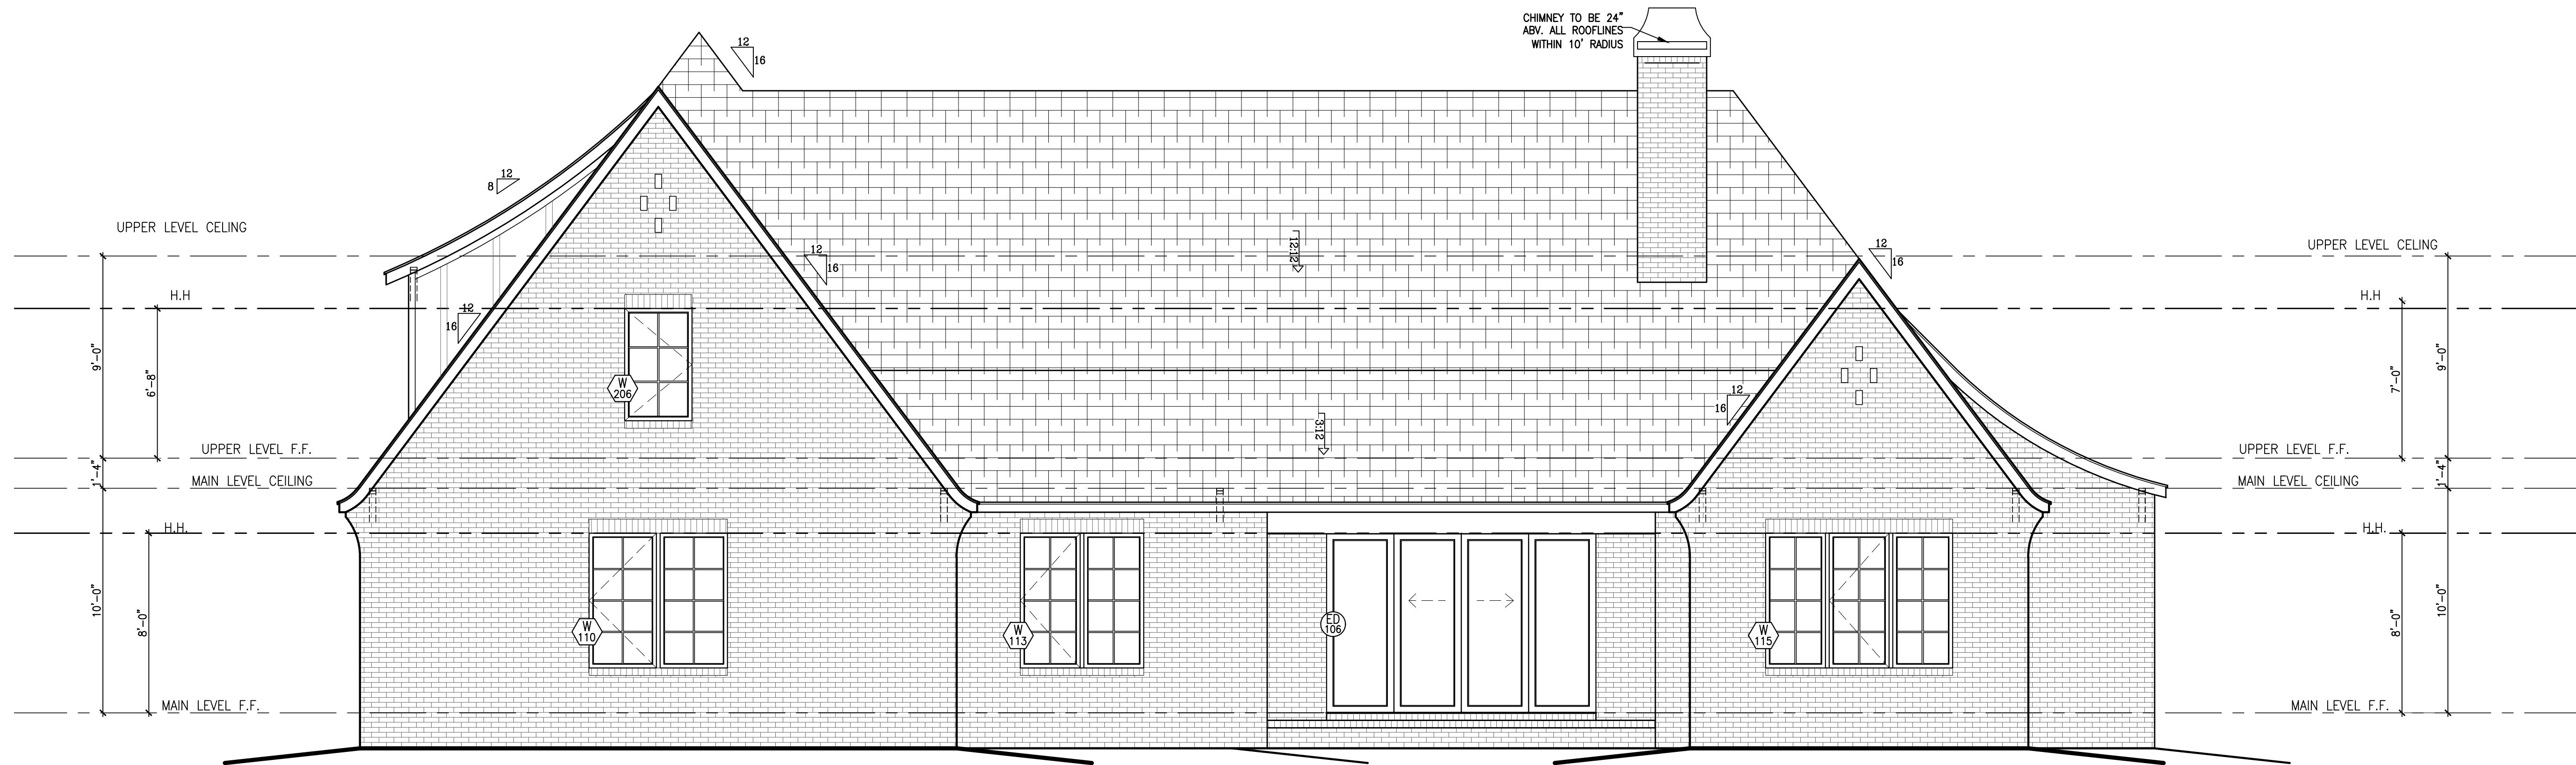

1 REAR ELEVATION
A-3.001 SCALE: 1/4" = 1'-0"

REVISION LOG:

NO.	DATE	REMARKS

DRAWN/CHECKED BY:

TC

ELEVATIONS
FOR
249 EASTON COURT
A NEW RESIDENCE IN
DOTHAN, ALABAMA



REEVES & SHAW
CONSTRUCTION

R&S CONSTRUCTION

REEVES AND SHAW CONSTRUCTION

Professional Consulting Engineers and Construction Services
3680 West Main Street - Dothan, Alabama 36305 334.677.5600

JOB NUMBER:


DATE:

February 26


SHEET TITLE & NO.

ELEVATIONS


A-3.001

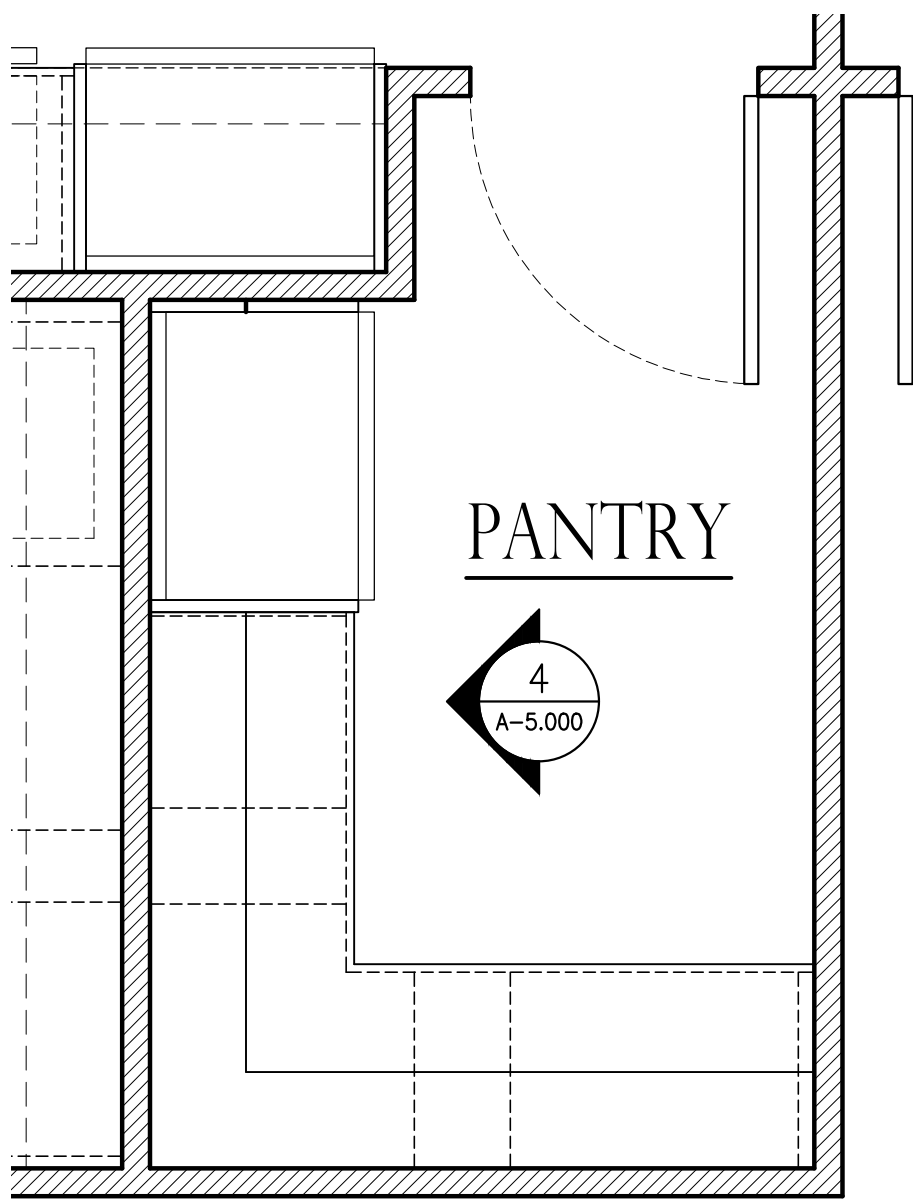


6 PANTRY FLOOR PLAN
SCALE: 1/2" = 1'-0"

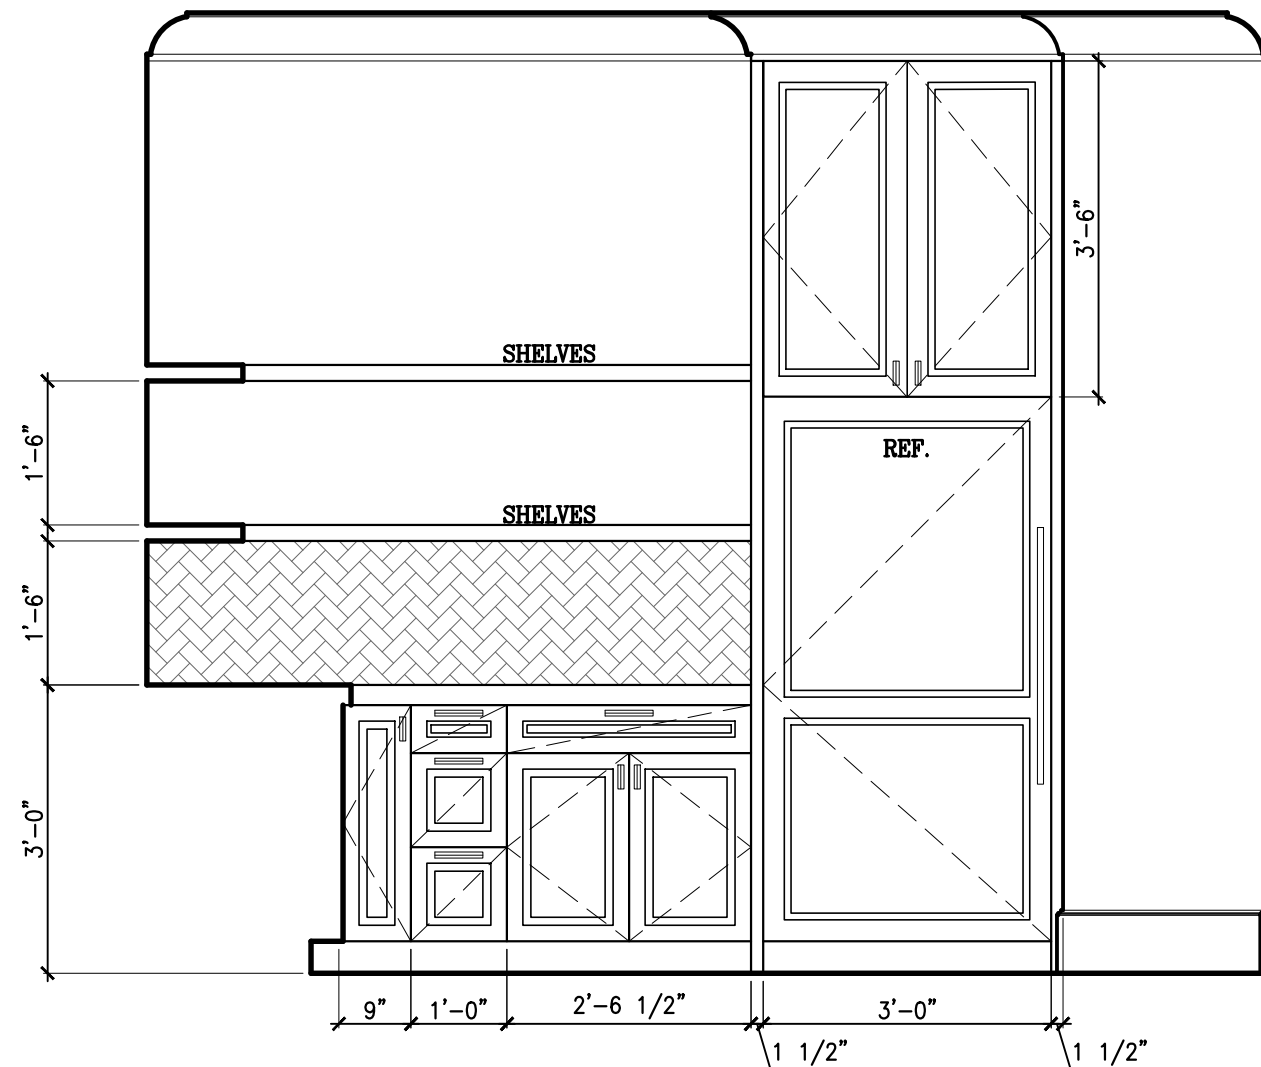


4 PANTRY FLOOR PLAN
SCALE: 1/2" = 1'-0"

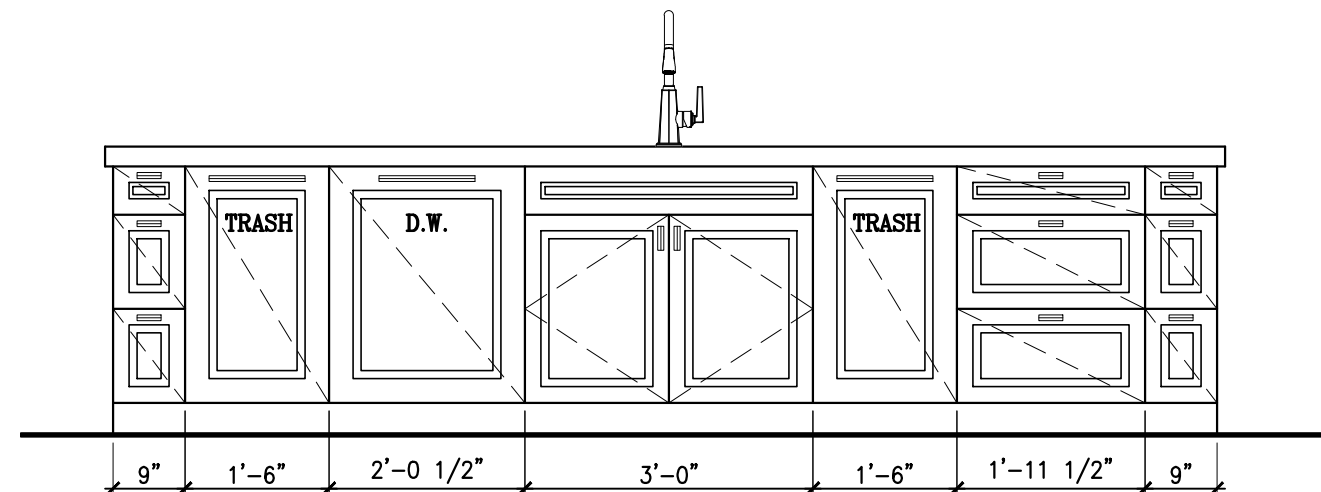


3 ISLAND ELEVATION
SCALE: 1/2" = 1'-0"

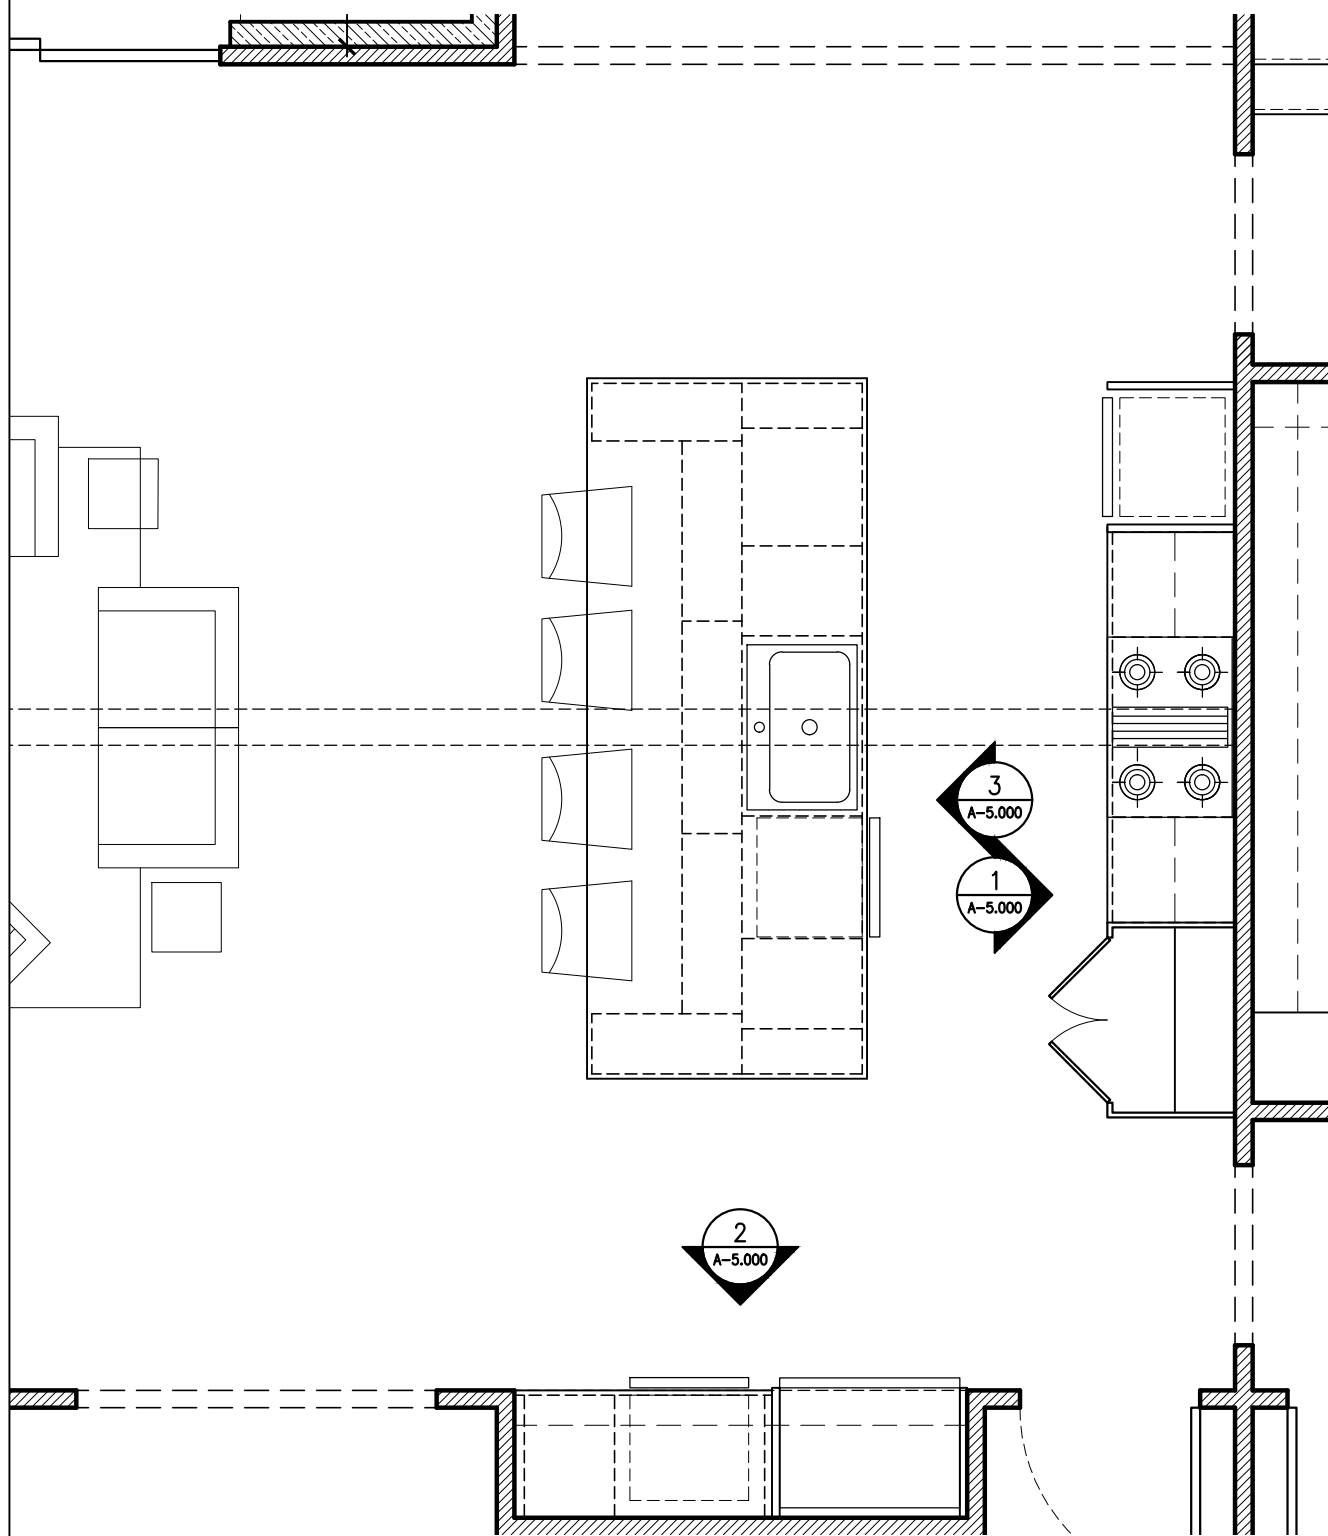

5 KITCHEN FLOOR PLAN
SCALE: 1/2" = 1'-0"

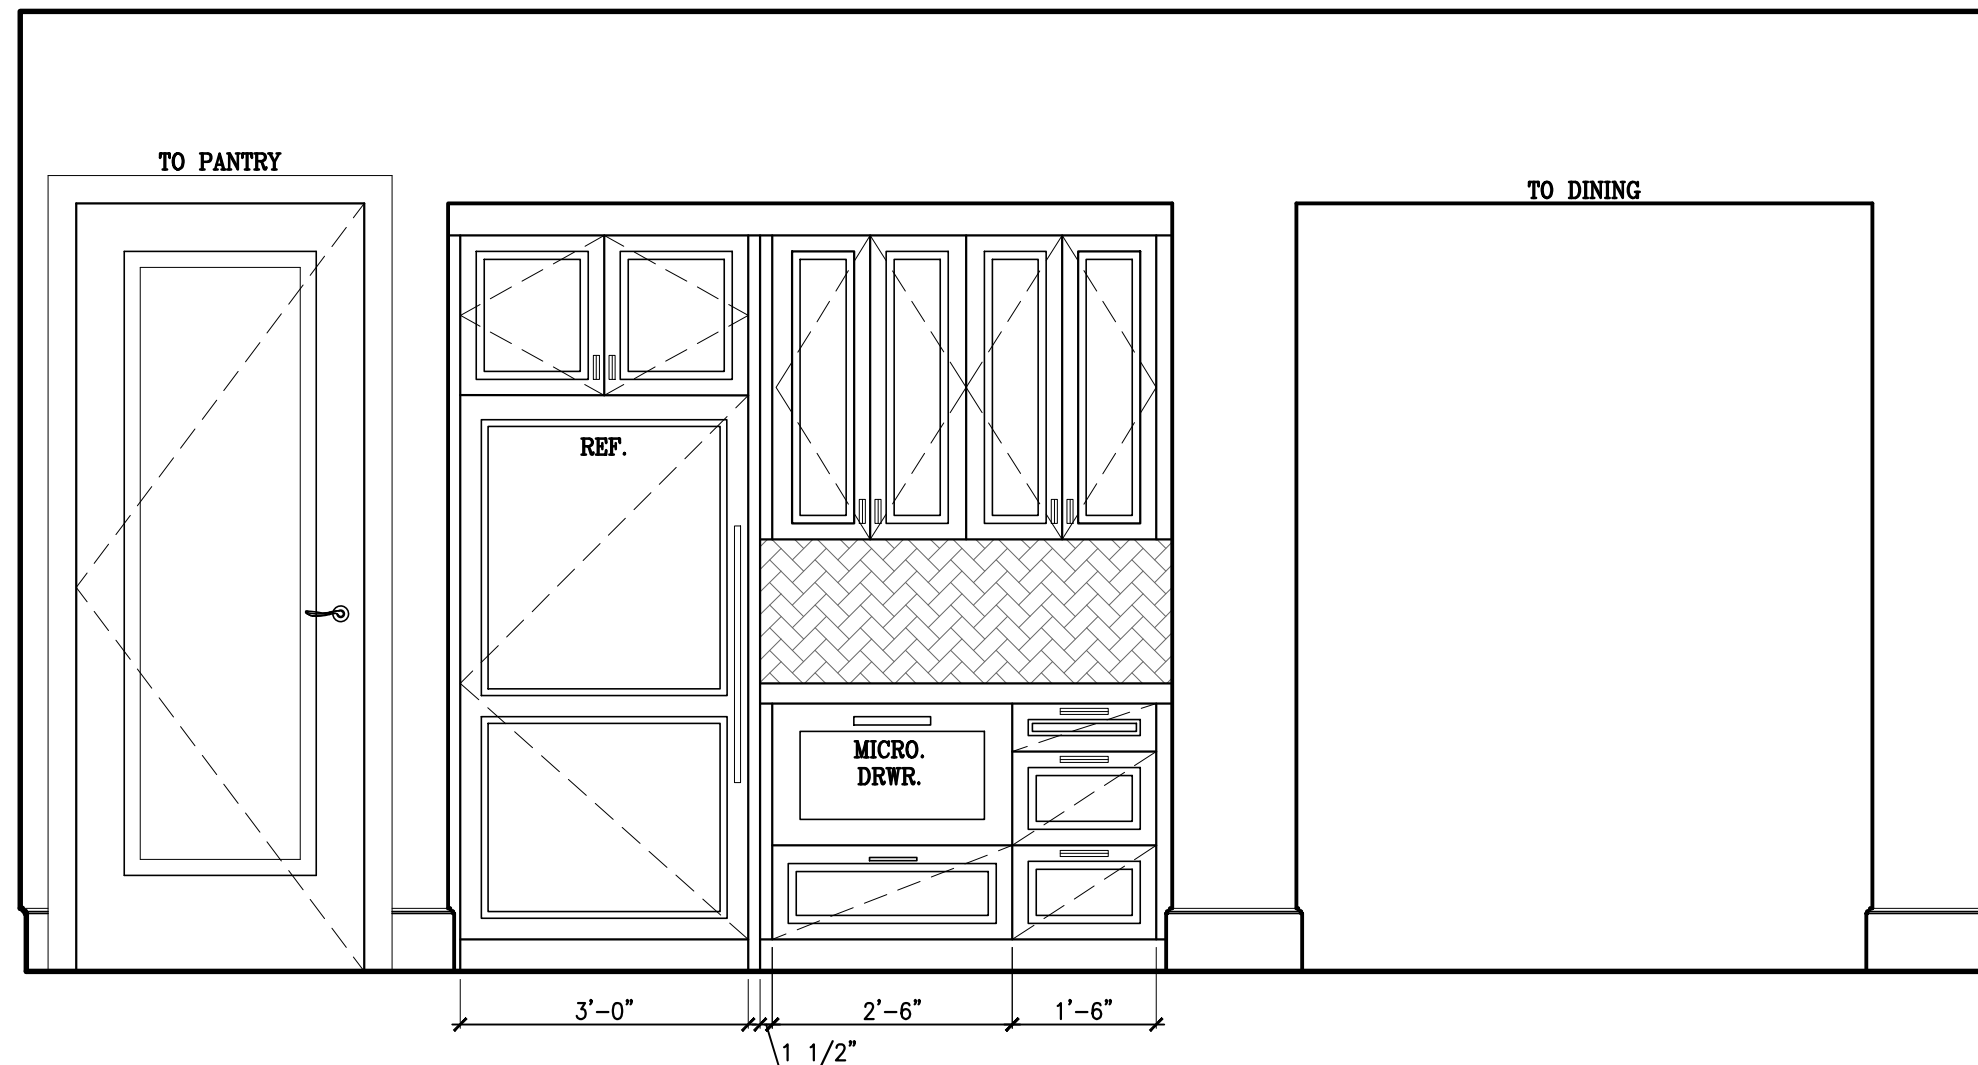

2 KITCHEN ELEVATION
SCALE: 1/2" = 1'-0"

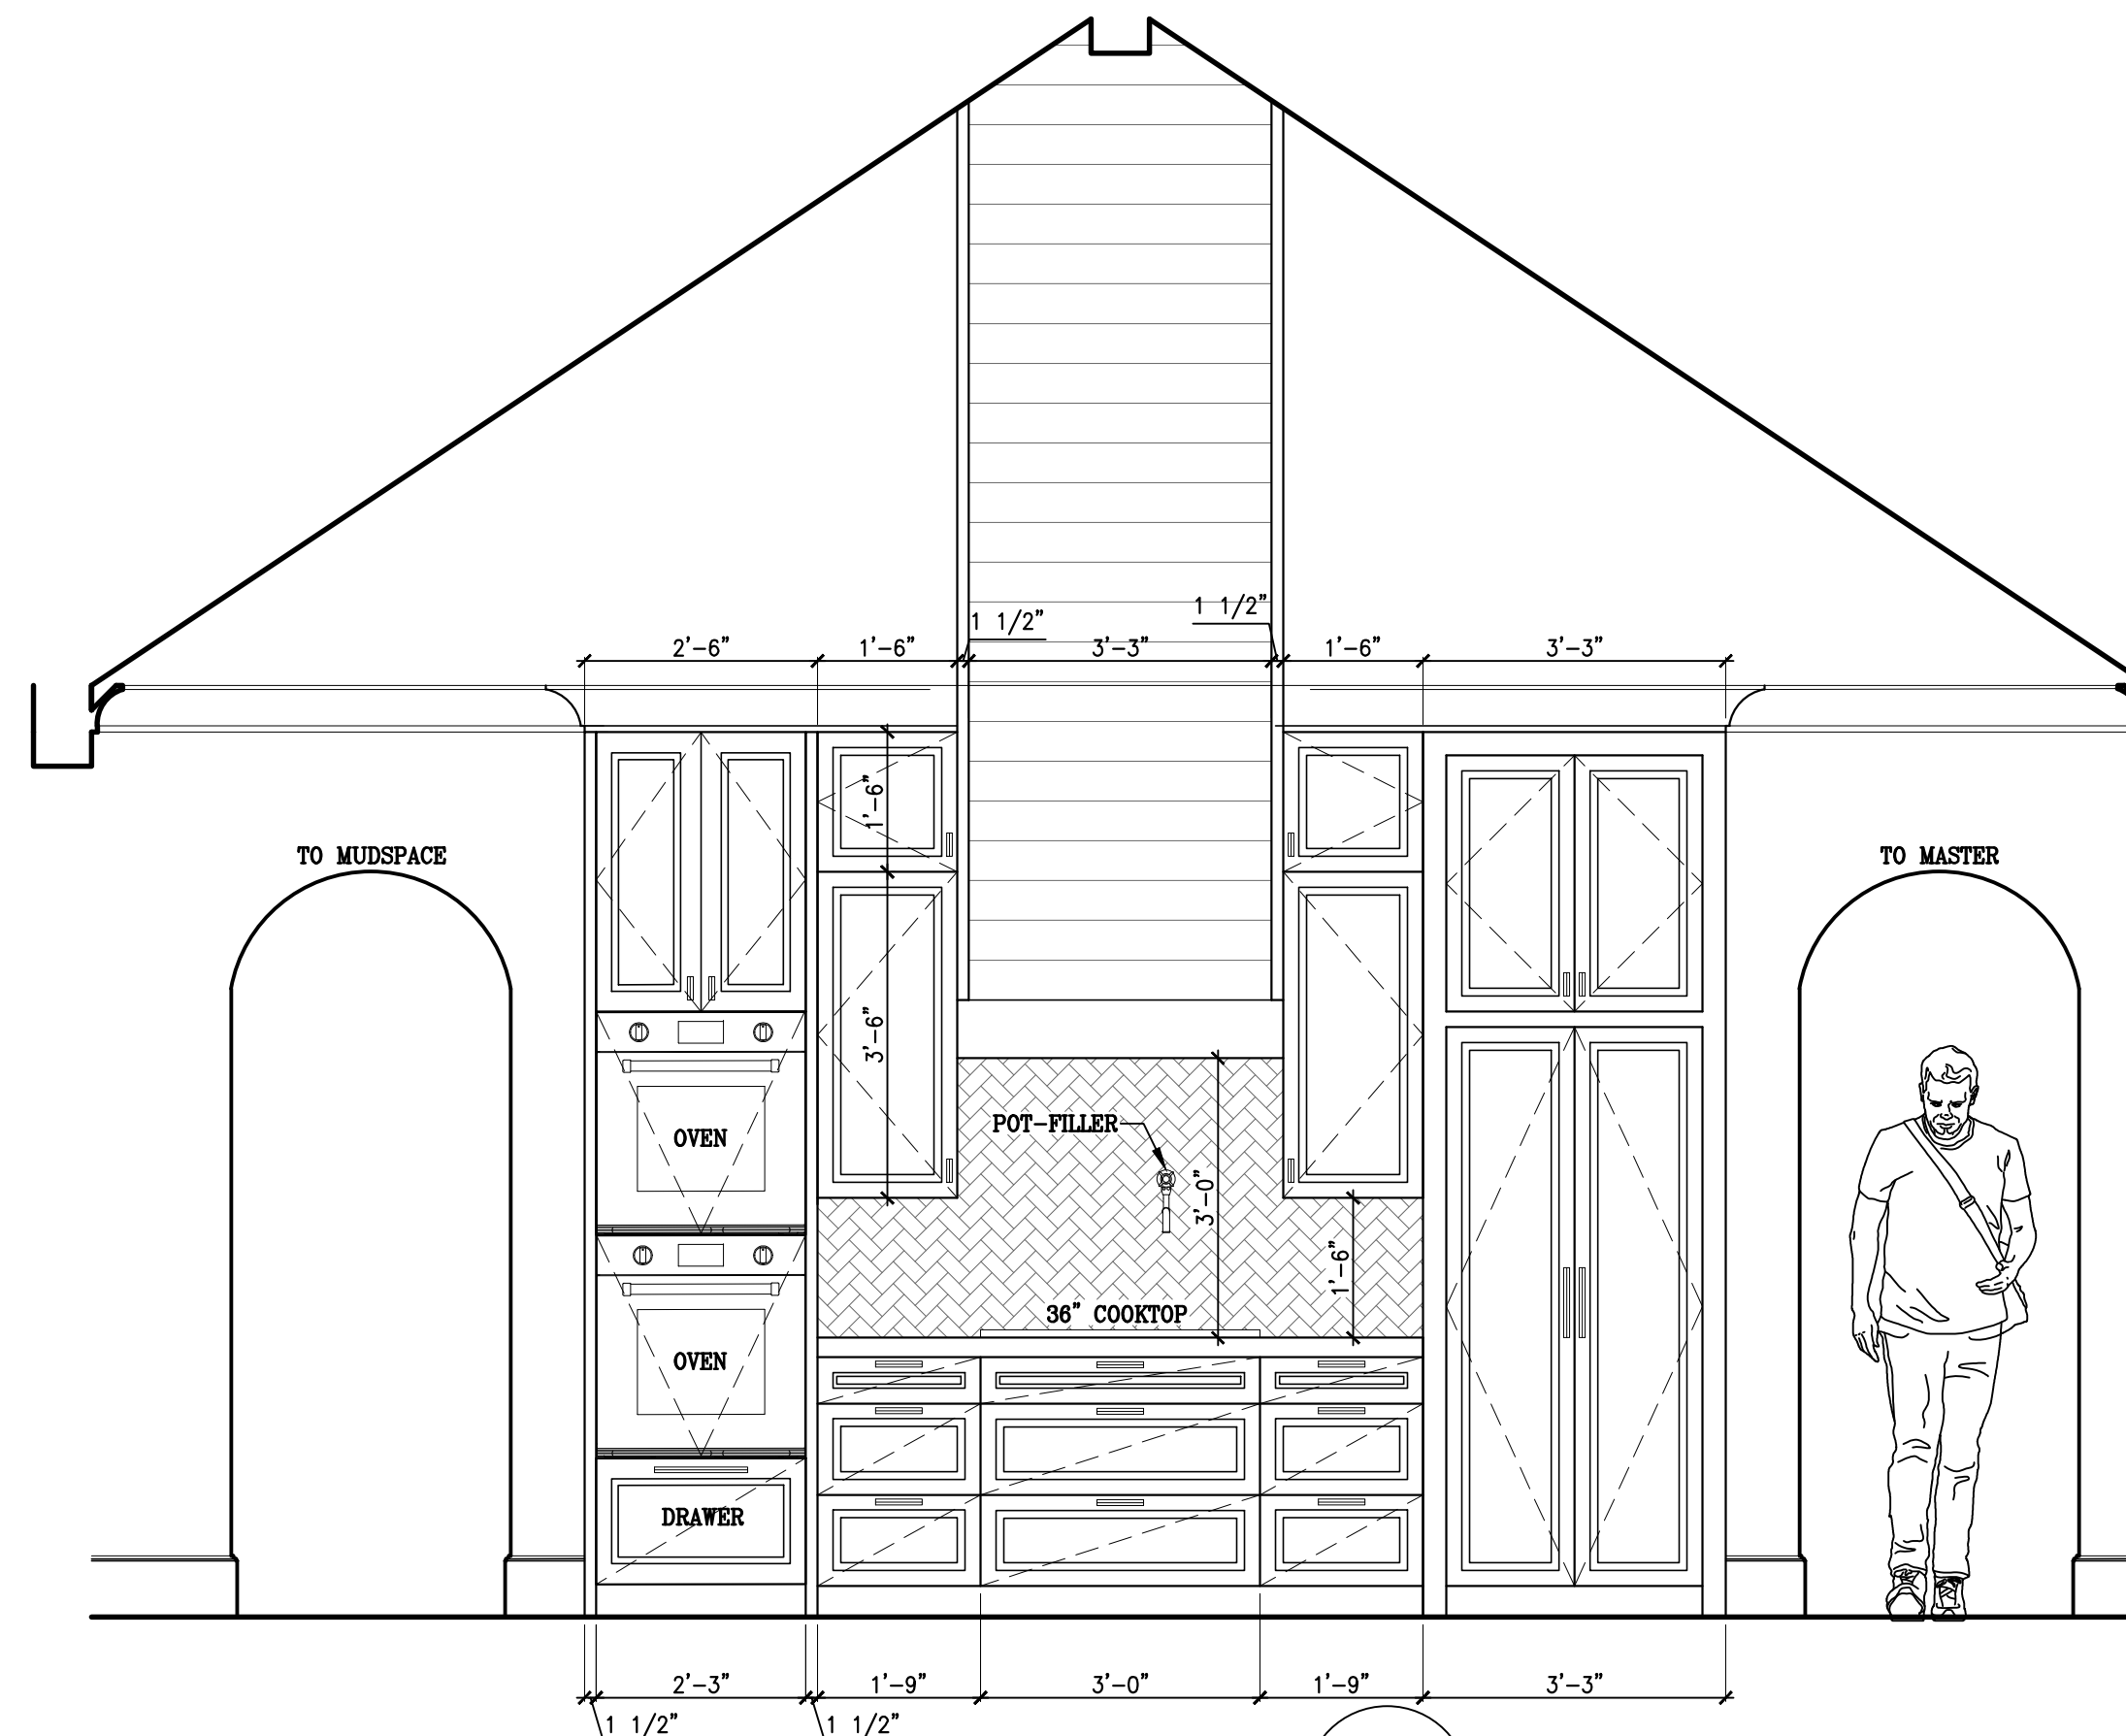

1 KITCHEN ELEVATION
SCALE: 1/2" = 1'-0"

REVISION LOG:

NO.	DATE	REMARKS

DRAWN/CHECKED BY:

TC

INTERIOR ELEVATIONS
FOR
249 EASTON COURT
A NEW RESIDENCE IN
DOTHAN, ALABAMA



R&S CONSTRUCTION
REEVES AND SHAW CONSTRUCTION
Professional Consulting Engineers and Construction Services
3680 West Main Street - Dothan, Alabama 36605 - 334.677.5600

JOB NUMBER:


DATE:

February 26


SHEET TITLE & NO.

INTERIOR ELEVATIONS


A-5.000

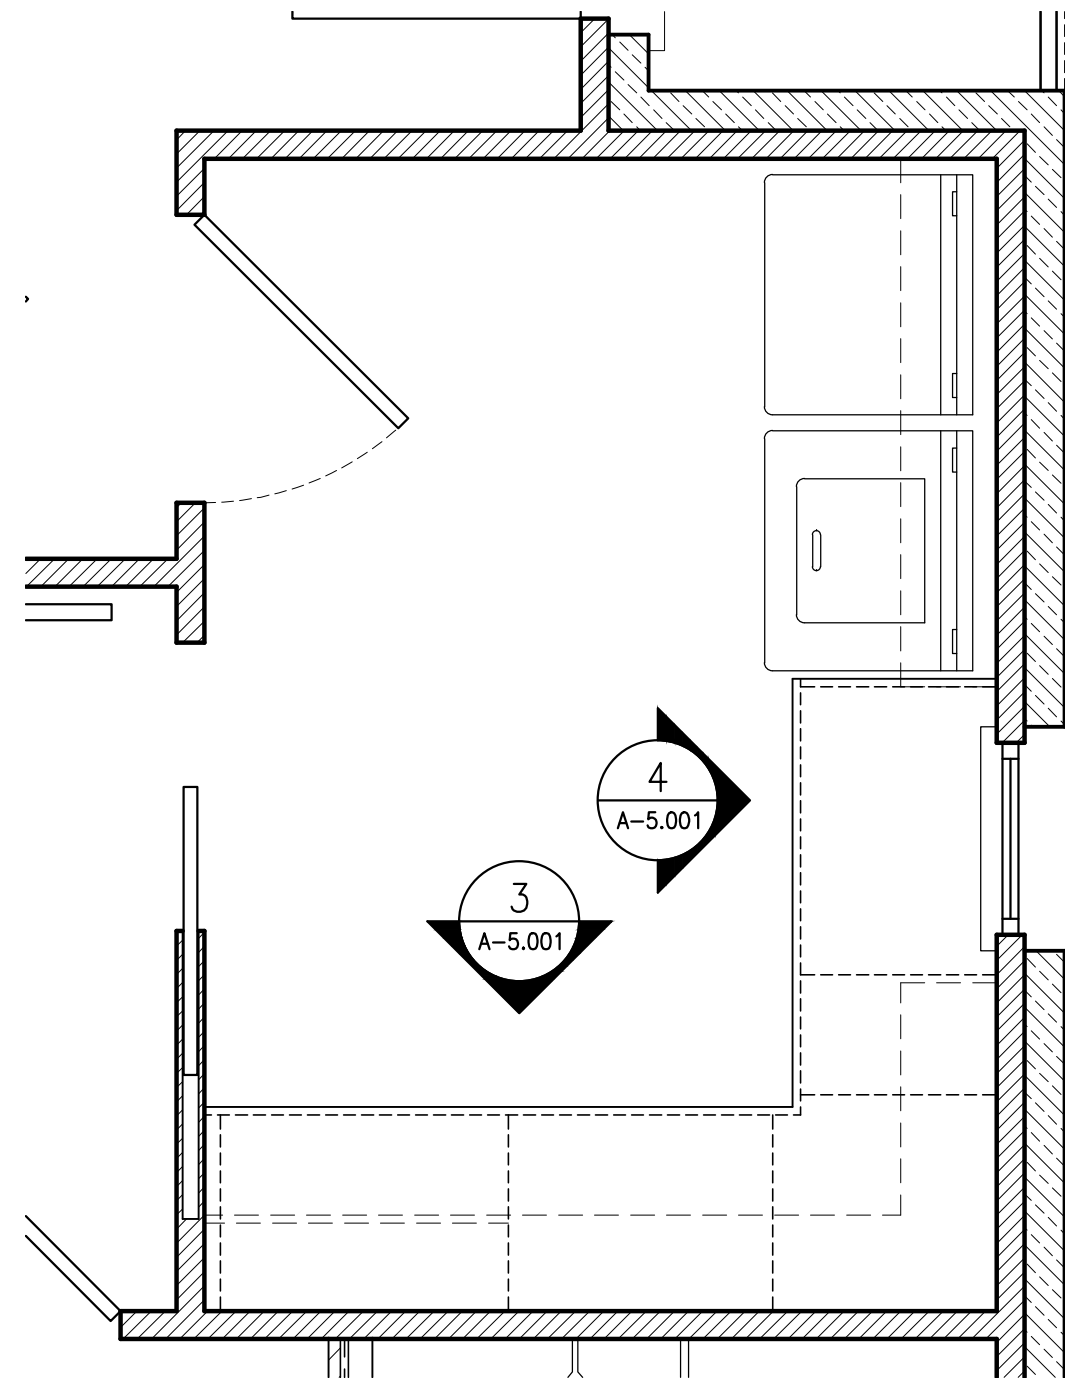


6 LAUNDRY FLOOR PLAN
A-5.001 SCALE: 1/2" = 1'-0"

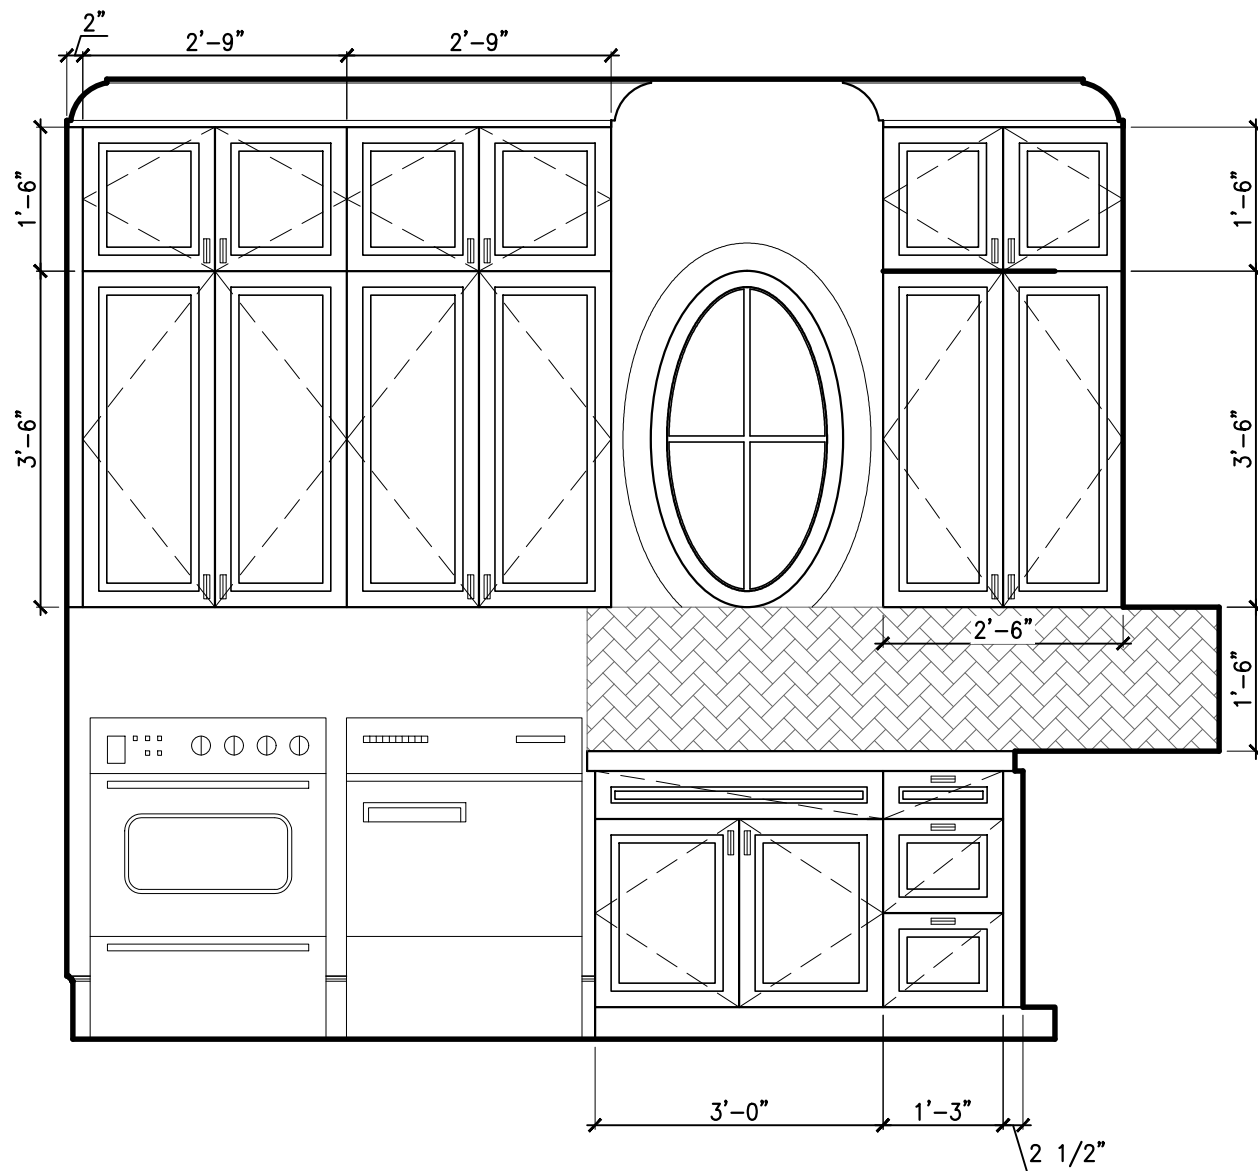


4 LAUNDRY ELEVATION
A-5.001 SCALE: 1/2" = 1'-0"

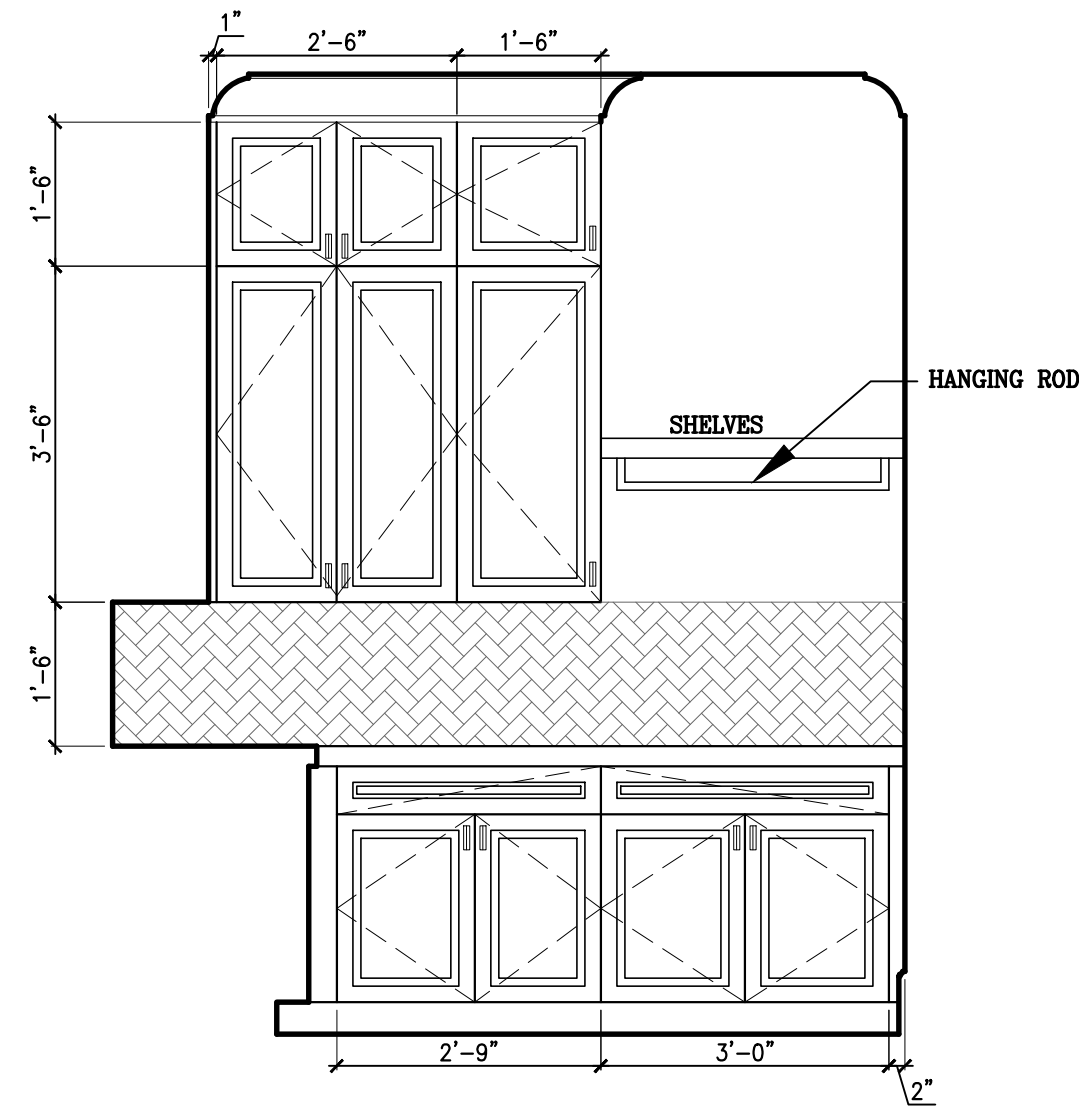


3 LAUNDRY ELEVATION
A-5.001 SCALE: 1/2" = 1'-0"

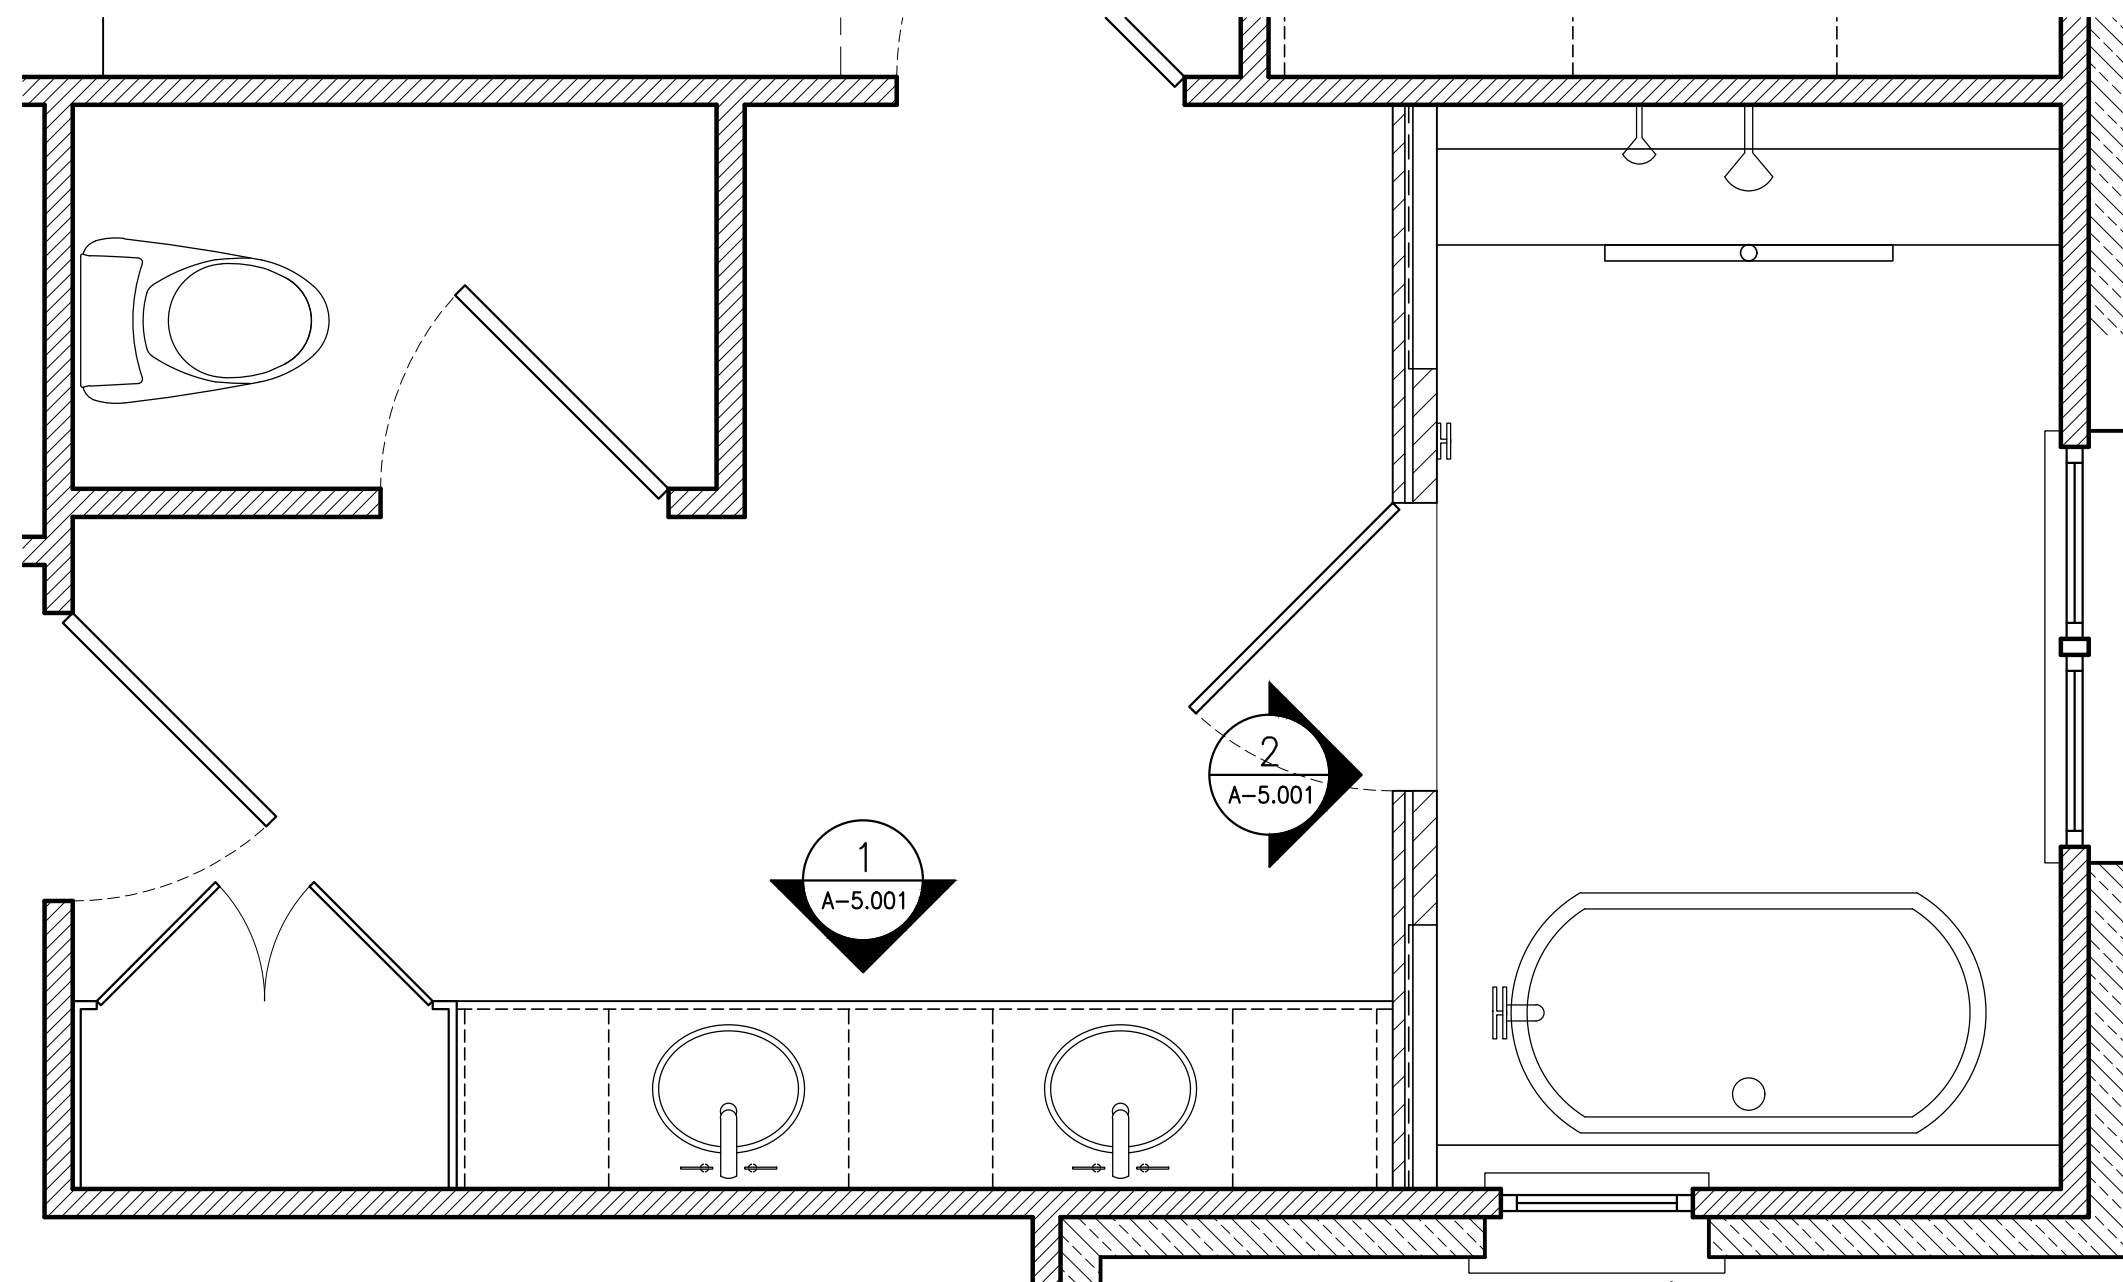

5 MASTER BATH FLOOR PLAN
A-5.001 SCALE: 1/2" = 1'-0"

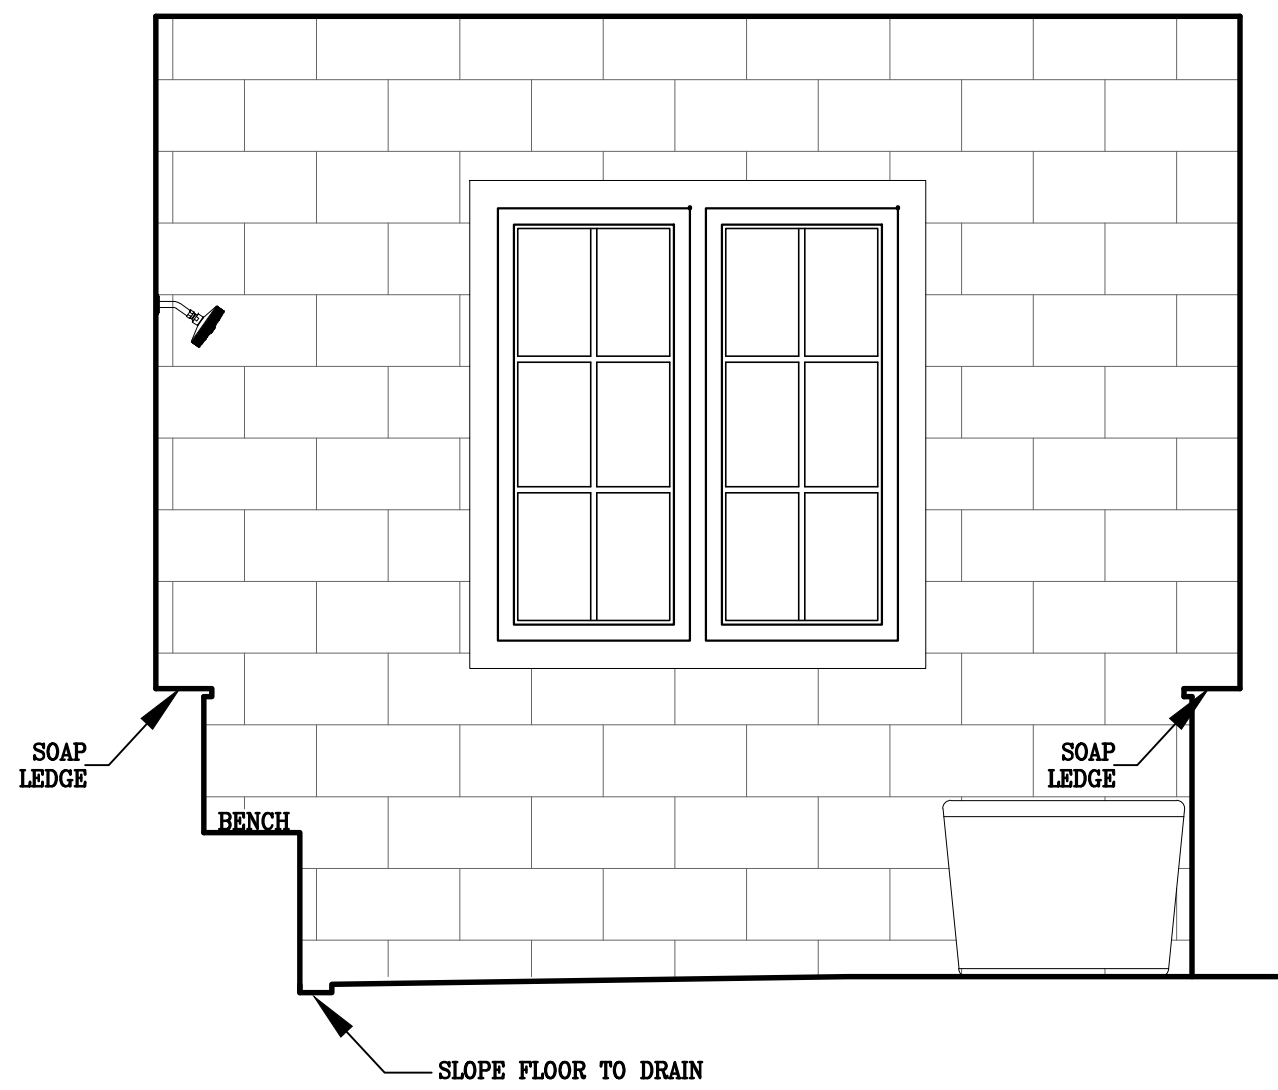

2 MASTER BATH ELEVATION
A-5.001 SCALE: 1/2" = 1'-0"

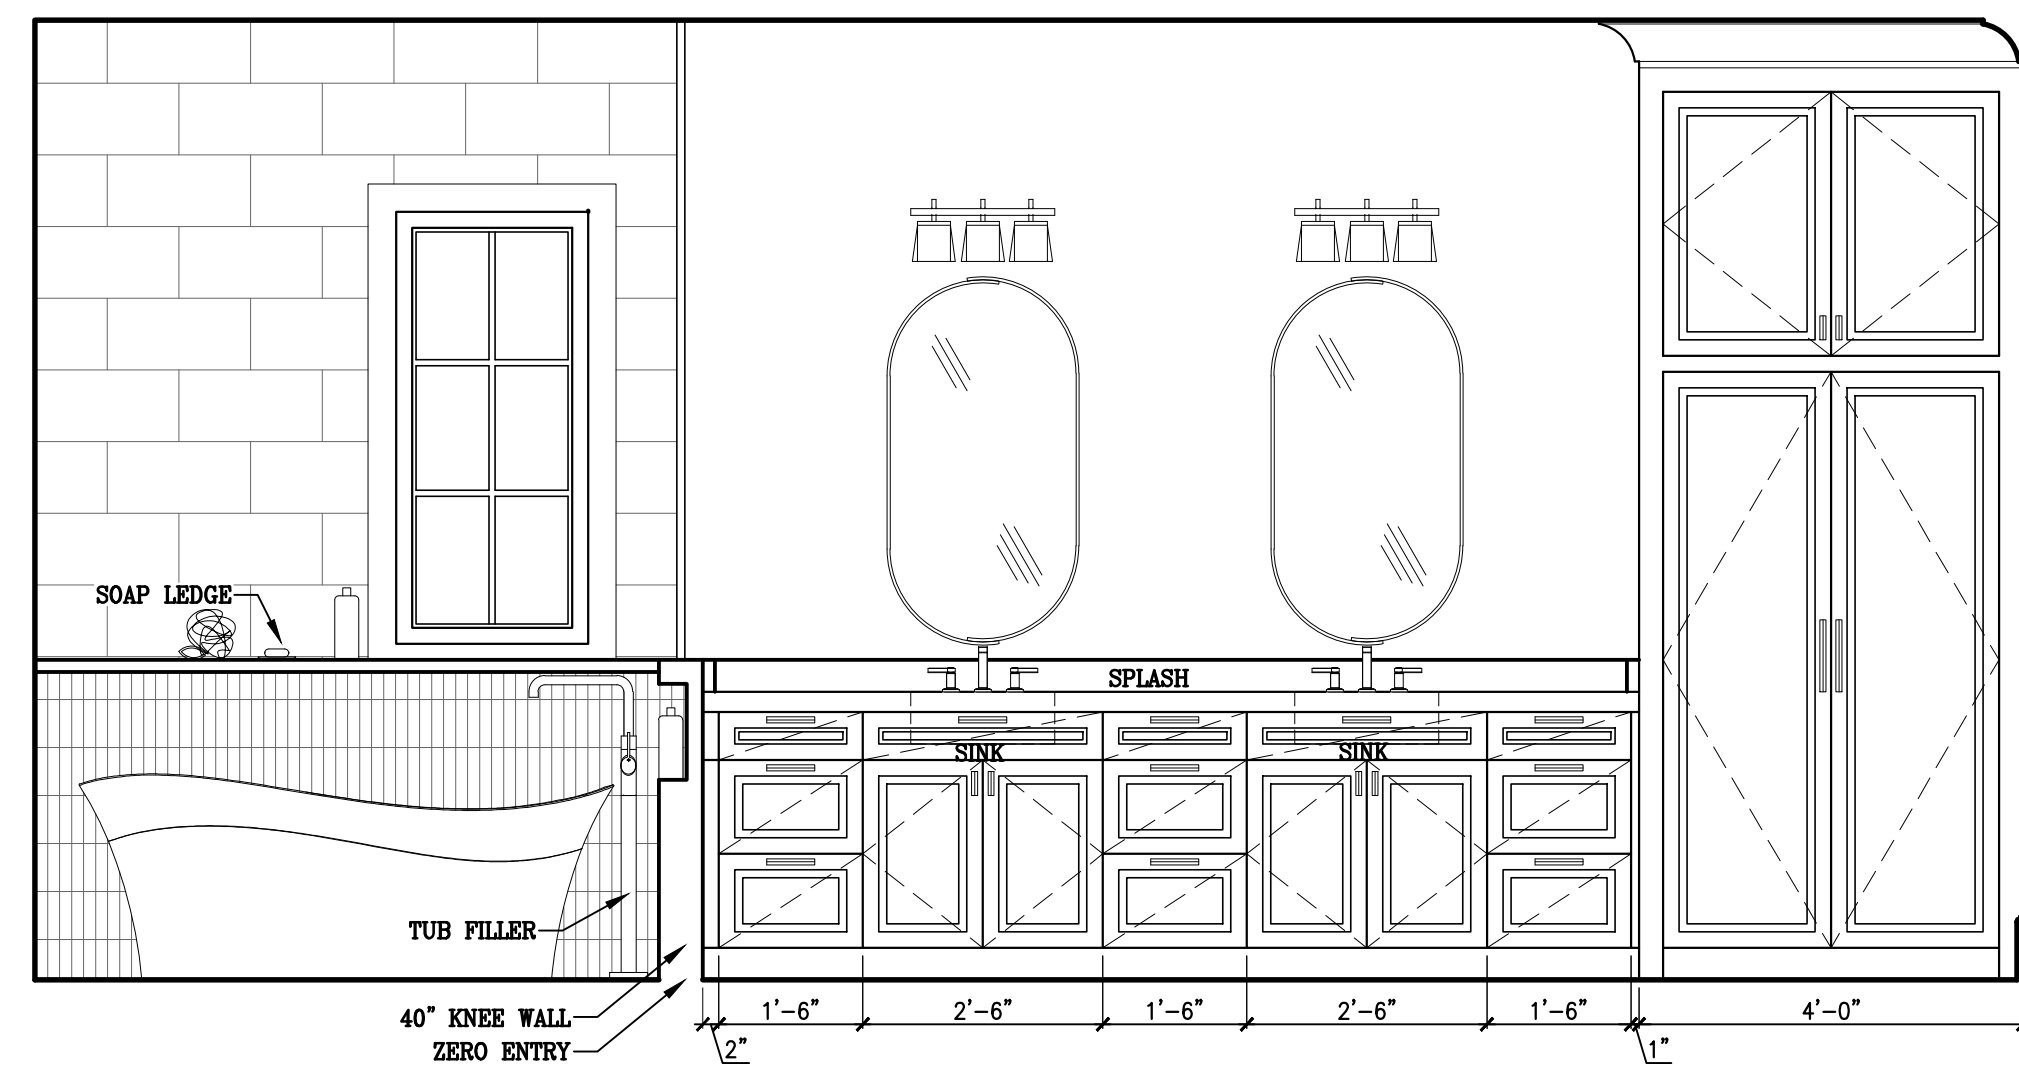

1 MASTER BATH ELEVATION
A-5.001 SCALE: 1/2" = 1'-0"

REVISION LOG:

NO. DATE REMARKS

DRAWN/CHECKED BY:

TC

INTERIOR ELEVATIONS
FOR
246 EASTON COURT
A NEW RESIDENCE IN
DOTHAN, ALABAMA



R&S CONSTRUCTION
REEVES AND SHAW CONSTRUCTION
Professional Consulting Engineers and Construction Services
3680 West Main Street - Dothan, Alabama 36505 334.677.5600

JOB NUMBER:


DATE:

February 26


SHEET TITLE & NO.

INTERIOR ELEVATIONS


A-5.001

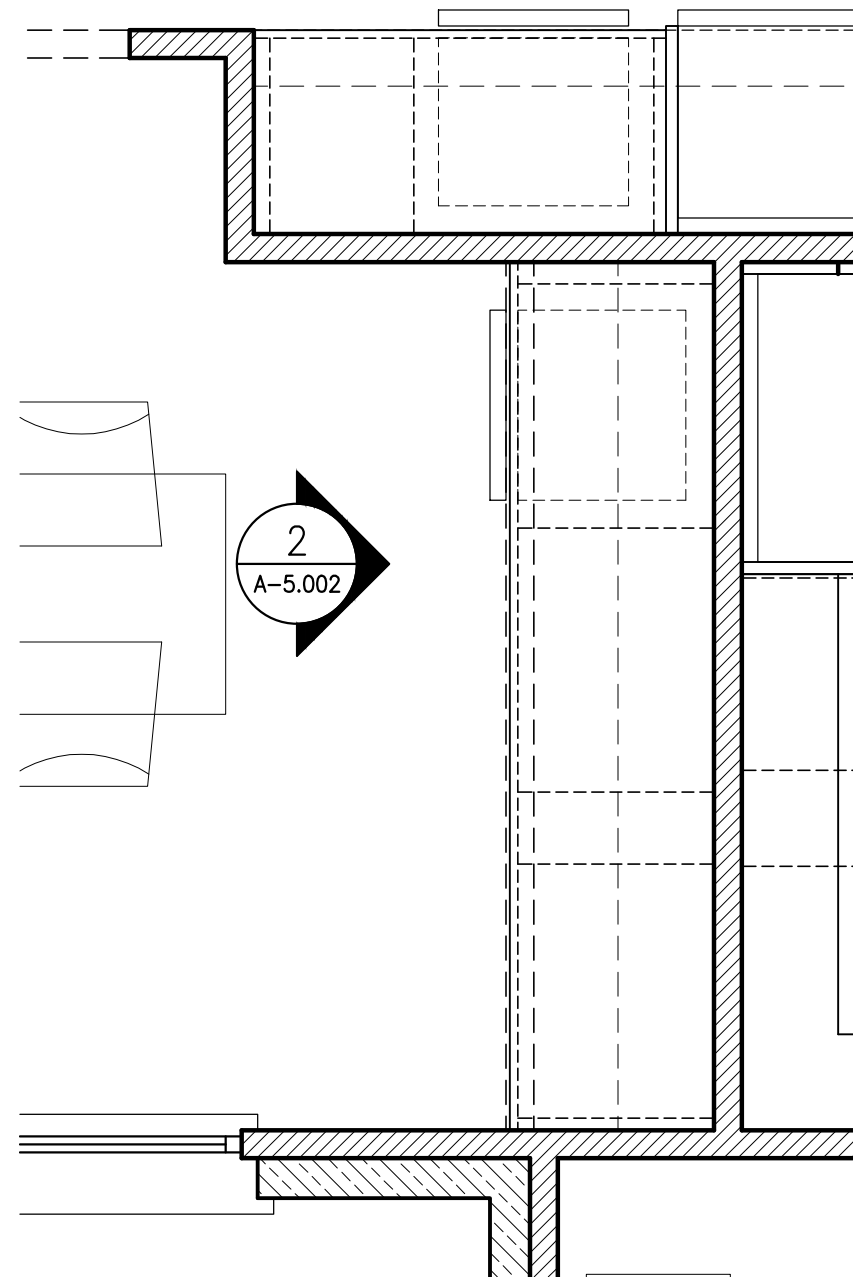


4 WINE BAR ELEVATION
A-5.002 SCALE: 1/2" = 1'-0"

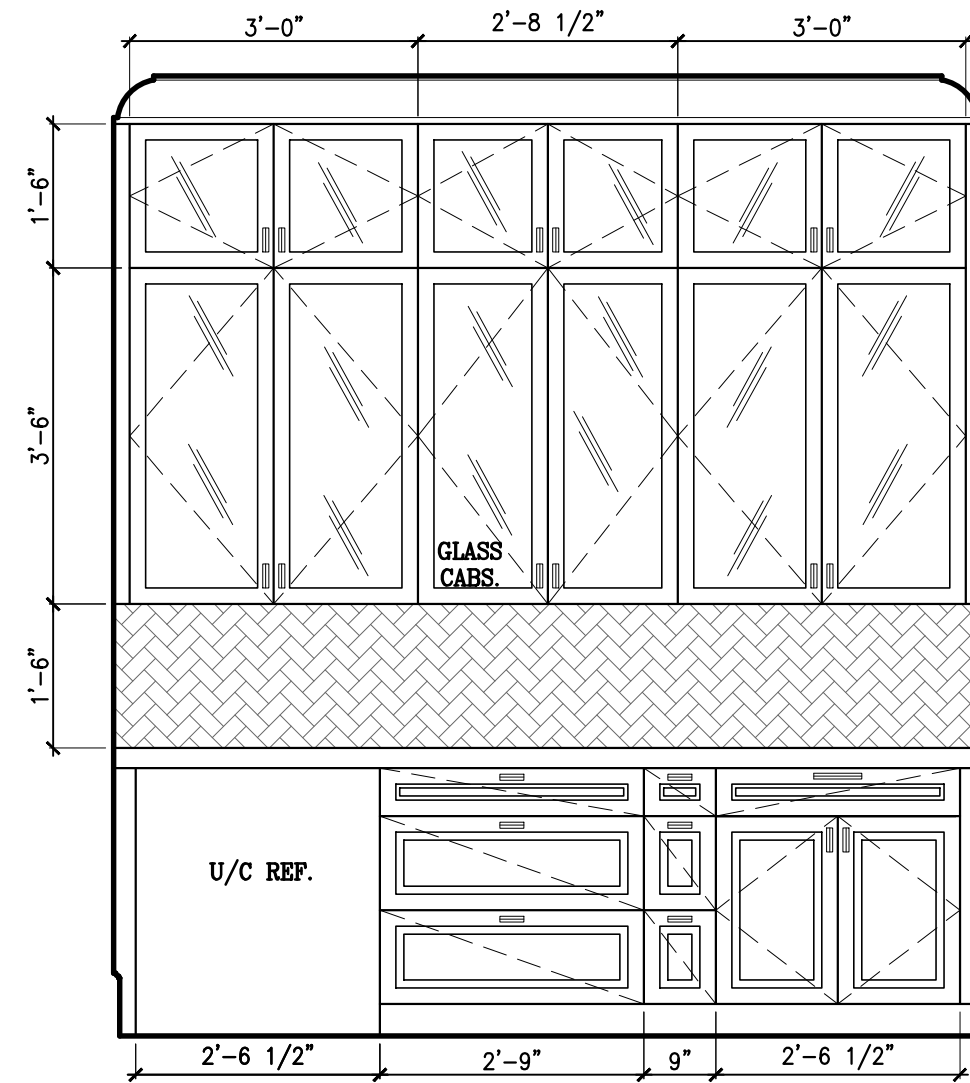

2 WINE BAR ELEVATION
A-5.002 SCALE: 1/2" = 1'-0"

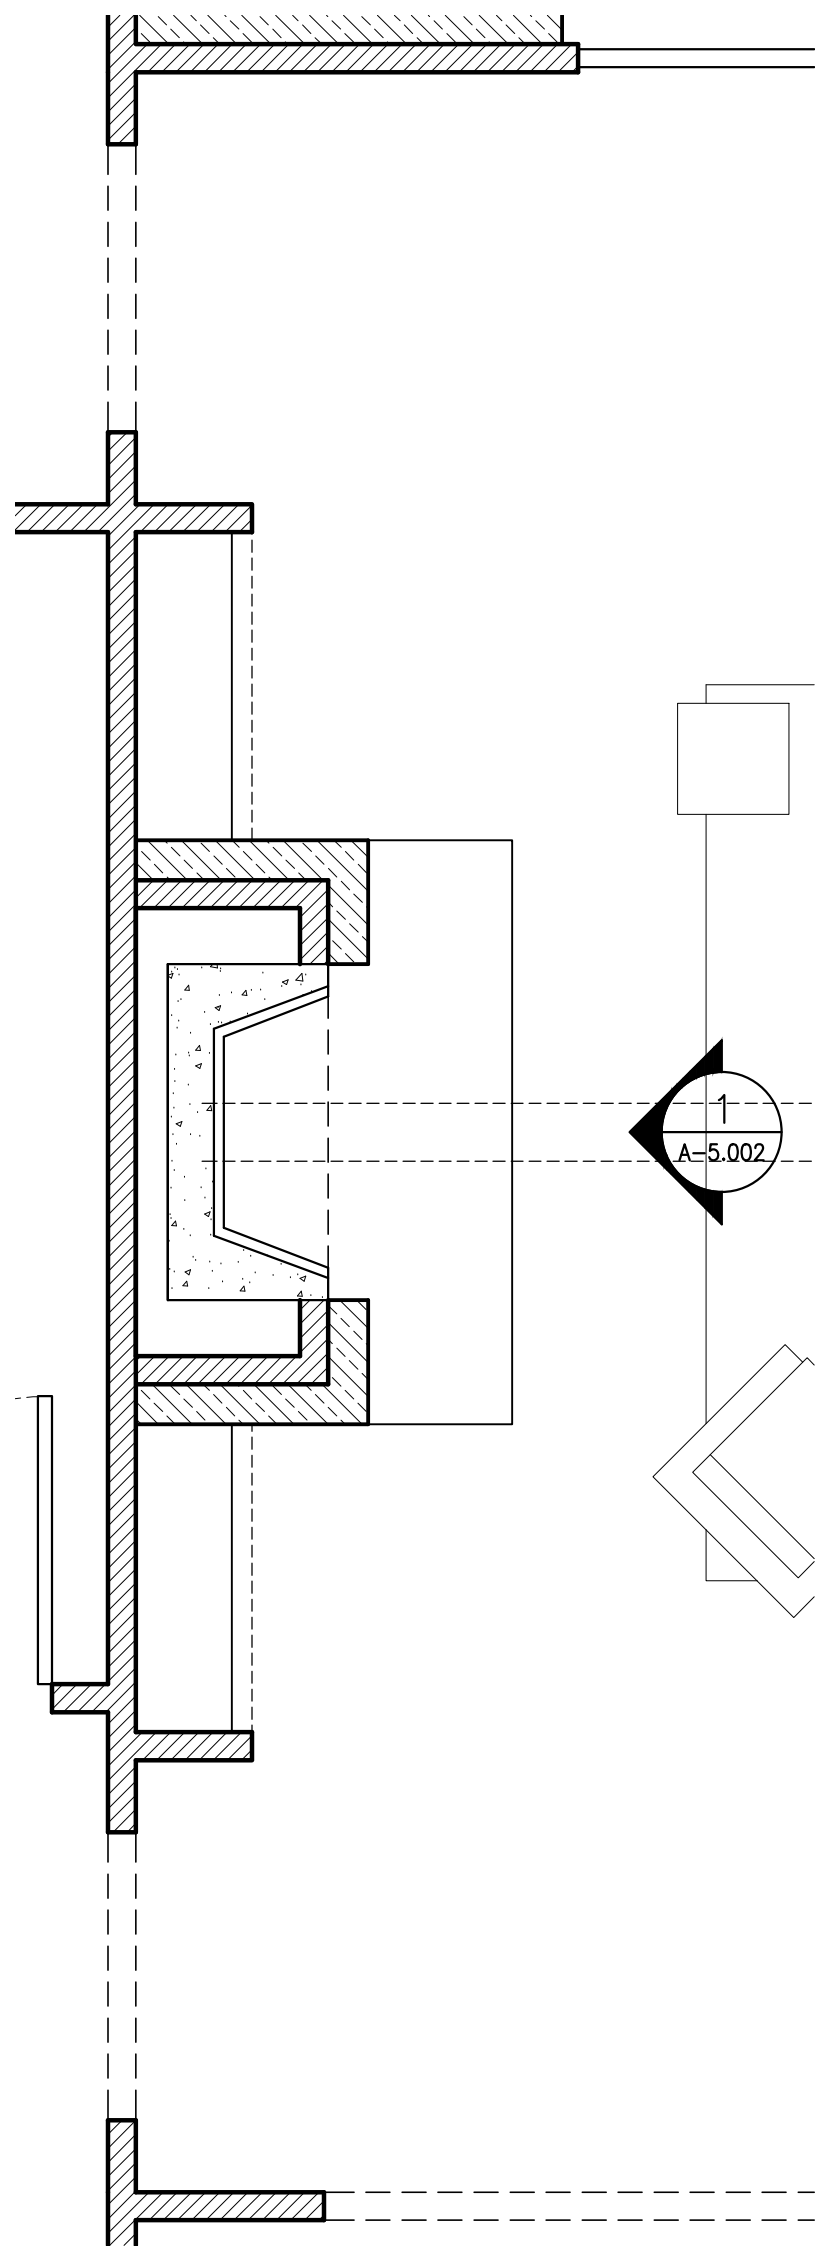

3 FIREPLACE FLOOR PLAN
A-5.002 SCALE: 1/2" = 1'-0"

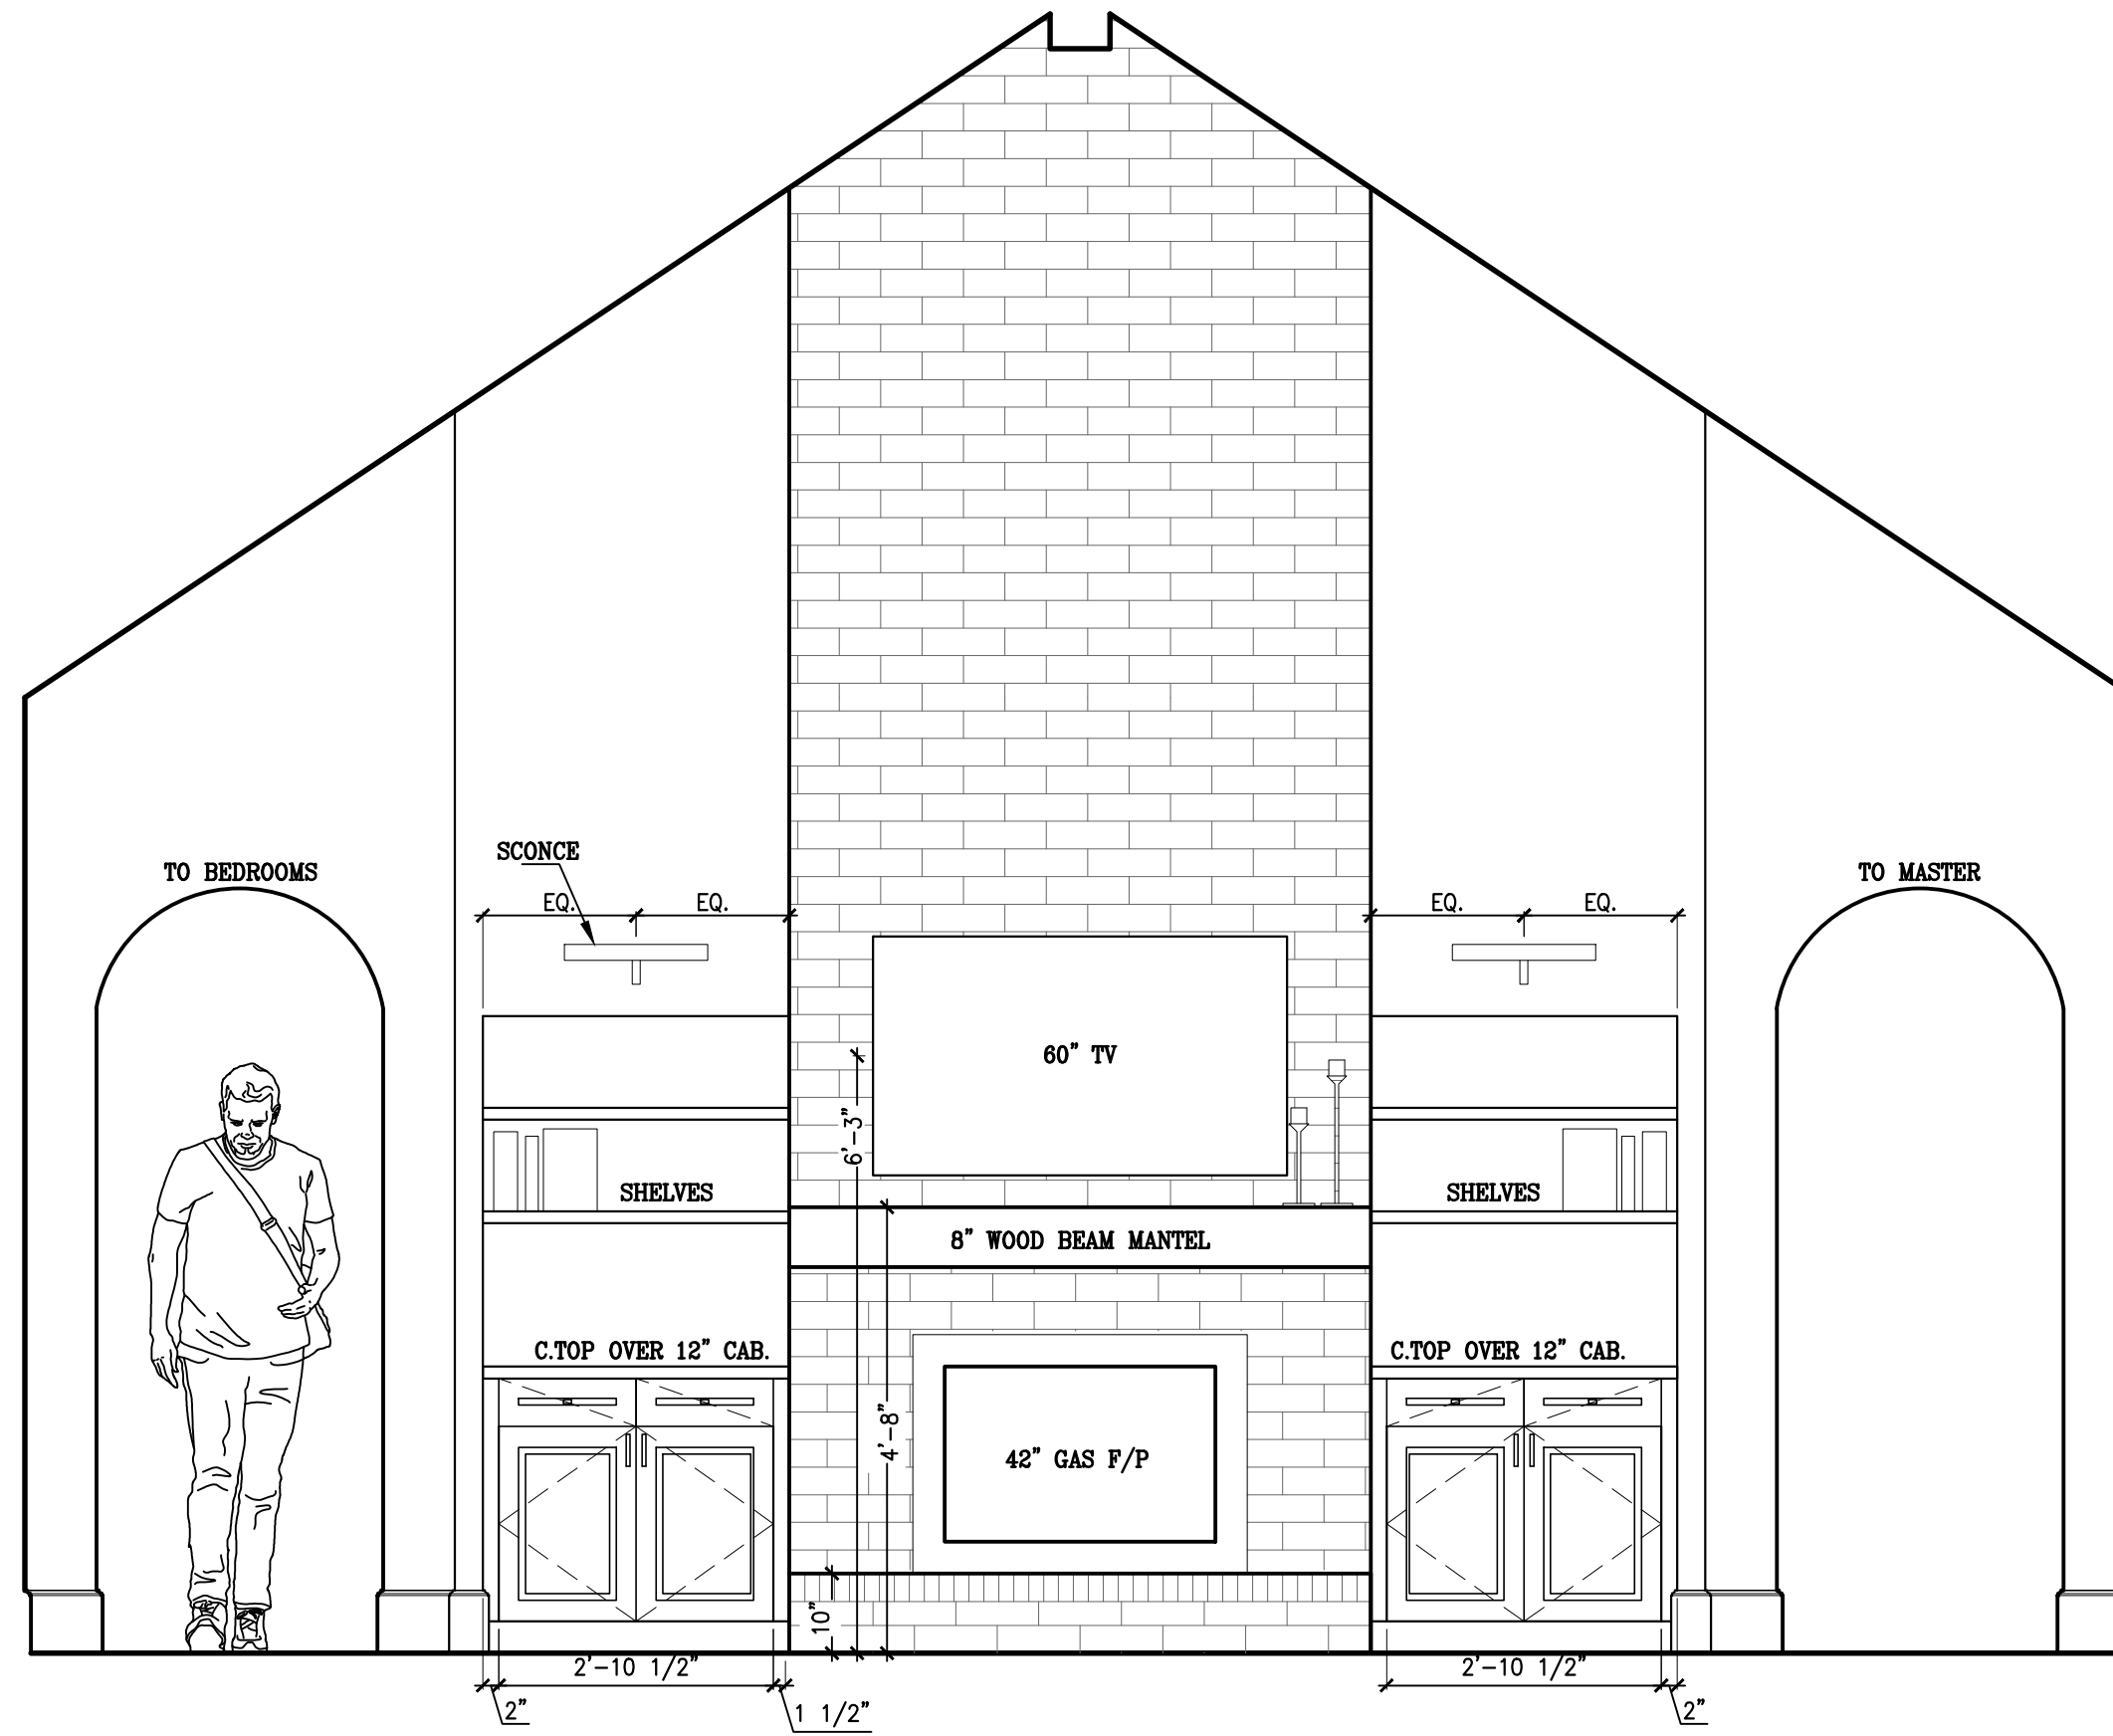

1 FIREPLACE ELEVATION
A-5.002 SCALE: 1/2" = 1'-0"

REVISION LOG:

NO.	DATE	REMARKS

DRAWN/CHECKED BY:

TC

INTERIOR ELEVATIONS
FOR
249 EASTON COURT
A NEW RESIDENCE IN
DOTHAN, ALABAMA



R&S CONSTRUCTION
REEVES AND SHAW CONSTRUCTION
Professional Consulting Engineers and Construction Services
3680 West Main Street - Dothan, Alabama 36305 334.677.5600

JOB NUMBER:


DATE:

February 26


SHEET TITLE & NO.

INTERIOR ELEVATIONS


A-5.002

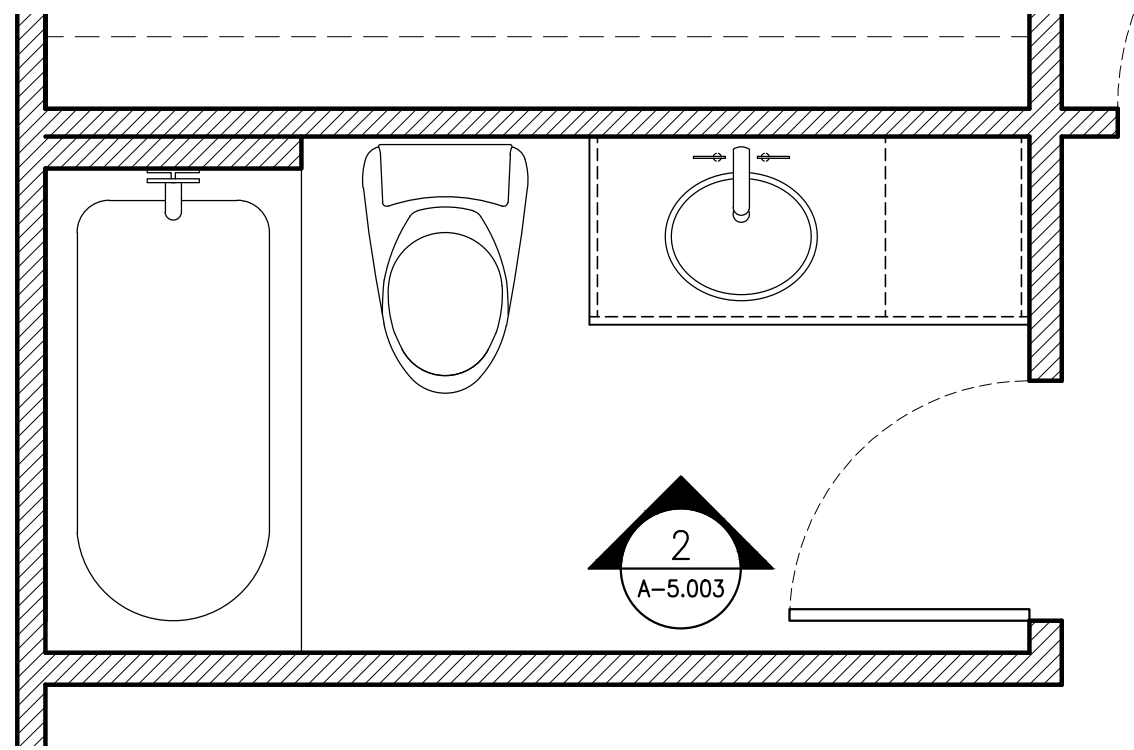


4 BATH #5 FLOOR PLAN
A-5.003 SCALE: 1/2" = 1'-0"

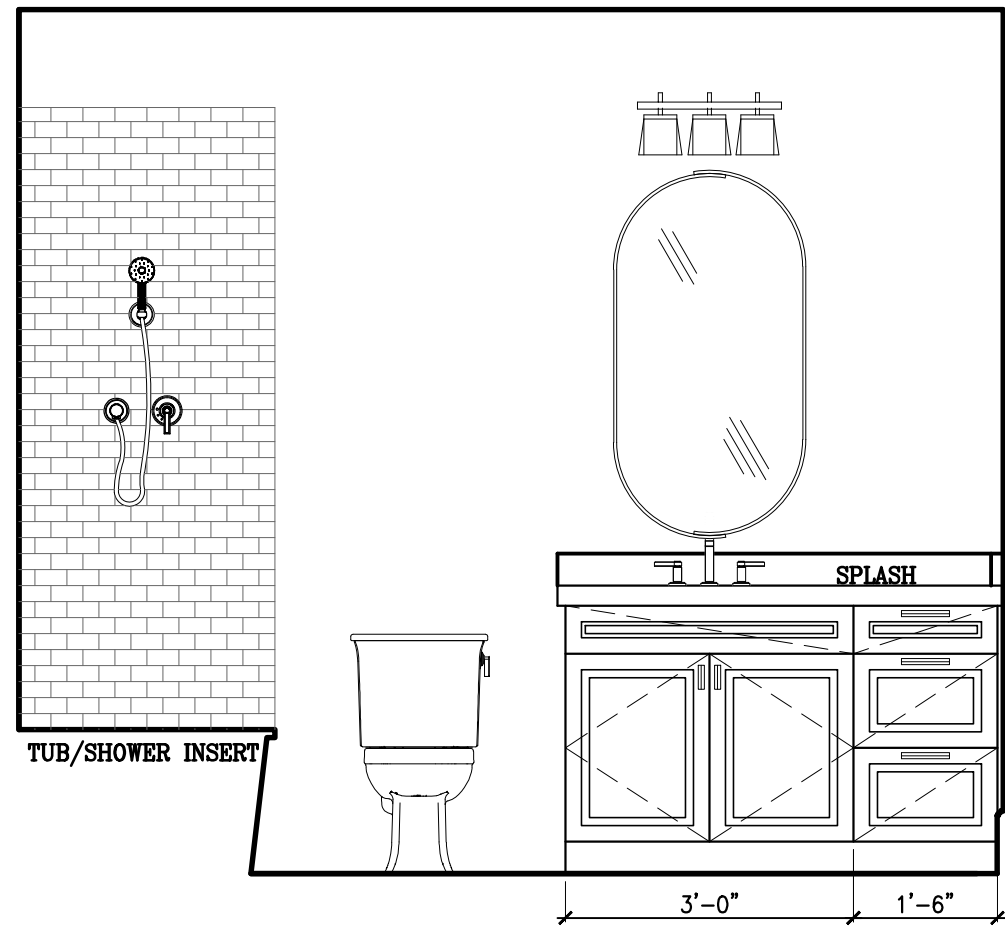

2 BATH #5 ELEVATION
A-5.003 SCALE: 1/2" = 1'-0"

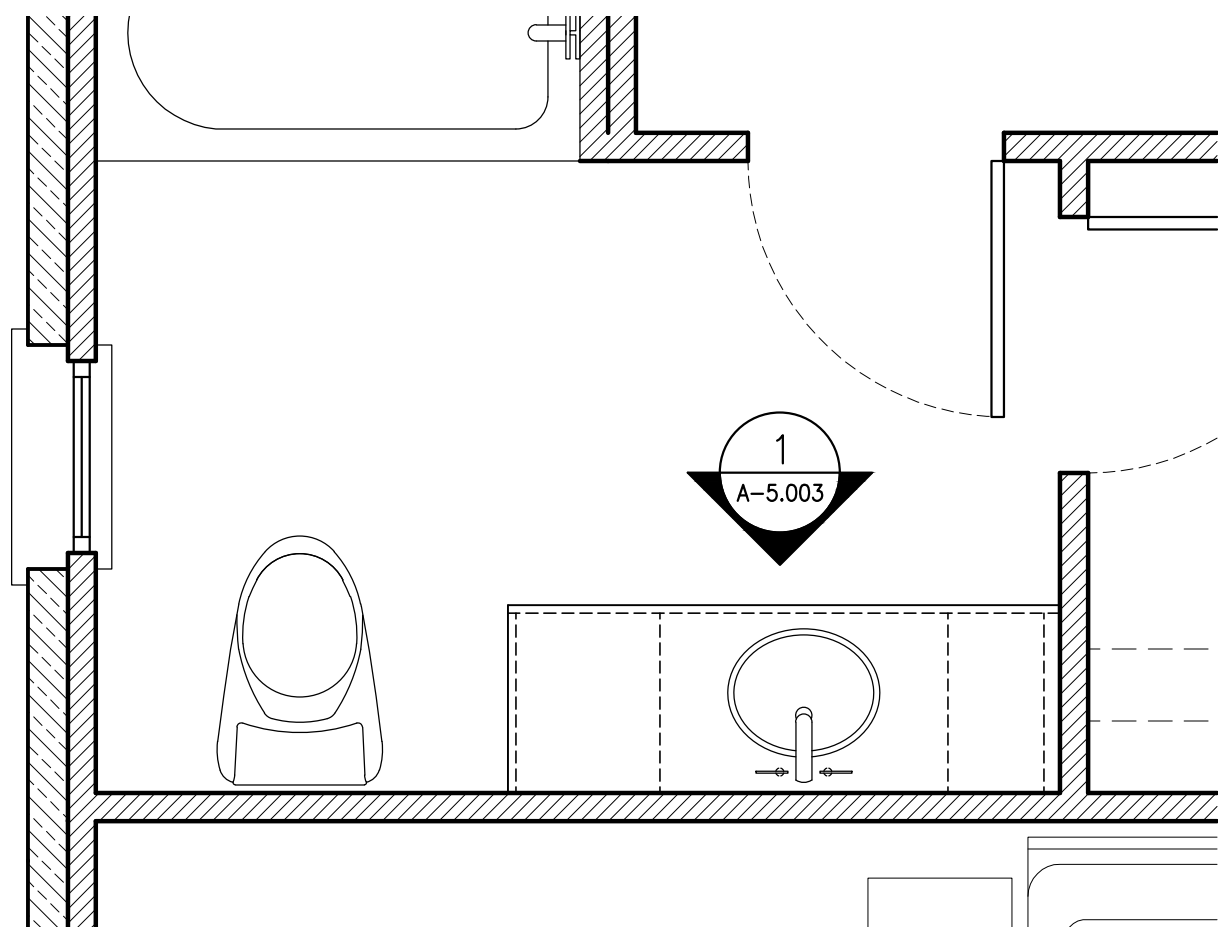

3 BATH #2, #3 AND #4 (#4 MIRRORED) FLOOR PLANS
A-5.003 SCALE: 1/2" = 1'-0"

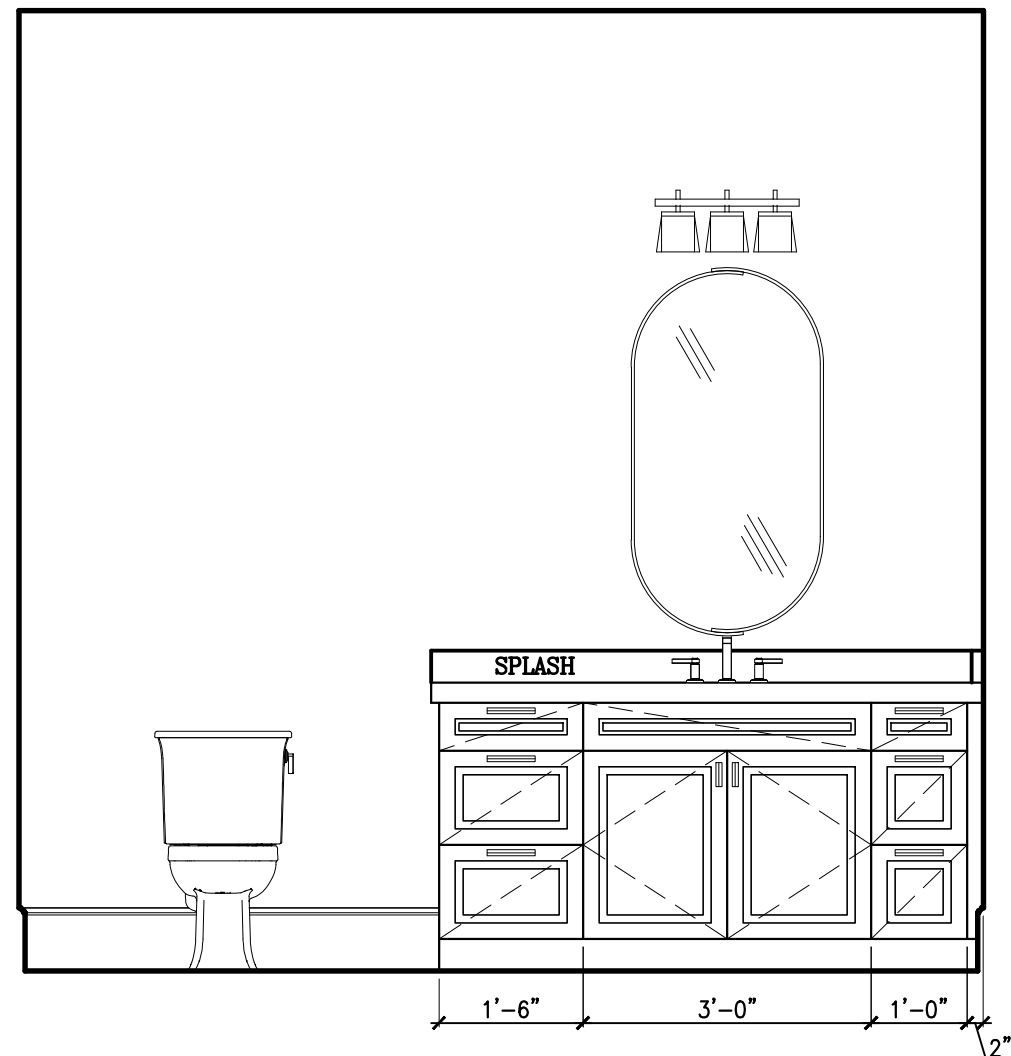

1 BATH #2, #3, AND #4 (#4 MIRRORED)
A-5.003 SCALE: 1/2" = 1'-0"

REVISION LOG:

NO.	DATE	REMARKS

DRAWN/CHECKED BY:

TC

INTERIOR ELEVATIONS
FOR
249 EASTON COURT
A NEW RESIDENCE IN
DOTHAN, ALABAMA



R&S CONSTRUCTION
REEVES AND SHAW CONSTRUCTION
Professional Consulting Engineers and Construction Services
3680 West Main Street - Dothan, Alabama 36305 334.677.5600

JOB NUMBER:

DATE:


February 26

SHEET TITLE & NO.

INTERIOR ELEVATIONS

A-5.003

LIGHTING & POWER LEGEND		
FIXTURE TYPE (E)EXISTING, (R)RE-USED, (N)NEW LED FIXTURE MODEL # - SEE LIGHT FIXTURE SCHEDULE	TH THERMOSTAT/HUMIDISTAT	
A1-E	T THERMOSTAT	
A1 RECESSED 6" CAN LIGHT FIXTURE	D DESIGNATED APPLIANCE OUTLET	
A2 RECESSED FIXTURE - DIRECTIONAL	USB DUAL OUTLET W/ USB PORTS	
A4 RECESSED LIGHT - APPROVED FOR WET AREAS	FLOOR MOUNTED QUAD OUTLET	
B1 CEILING MOUNTED FIXTURE	C CEILING MOUNTED OUTLET	
S WALL MOUNTED FIXTURE	FLOOR MOUNTED OUTLET	
E EXTERIOR WALL MOUNTED FIXTURE	DUAL OUTLET	
G EXTERIOR WALL MOUNTED GAS FIXTURE	GF DUAL OUTLET W/ GROUND FAULT INTERRUPTER	
F RECESSED CEILING FAN	WP DUAL OUTLET W/ WEATHERPROOF	
FC RECESSED CAN LIGHT WITH INTEGRATED CEILING FAN	QUAD OUTLET	
HEAD HEADER MOUNTED FLUORESCENT	R RANGE OUTLET 125/250V	
FLUORESCENT FIXTURE 2X4	PHONE JACK	
M UNDER CABINET LIGHT - SIZE VARIES	TV CABLE TV JACK, REQ'D OUTLET & DATA	
LED UNDERMOUNT LED STRIPS	S SMOKE DETECTOR / CARBON MONOXIDE DETECTOR	
CEILING FAN (WIRE FOR SEPERATE LIGHT & FAN CONTROLS) (DIA. VARIES)	D DATA OUTLET (NETWORK)	
MOTION ACTIVATED FLOOD LIGHT	DIRECT CONNECTION TO FIXED EQUIPMENT	
LANDSCAPE UPLIGHTING	J JUNCTION BOX - CEILING MOUNTED	
WIRING IN CONDUIT RUN CONCEALED IN WALL/FLOOR/CEILING	J JUNCTION BOX - WALL MOUNTED	
NTWK NETWORK PANEL		
D DIMMER SWITCH		
S SWITCH		
3 THREE WAY SWITCH		
4 FOUR WAY SWITCH		
WP SWITCH WITH WEATHERPROOF		
3 THREE WAY SWITCH WITH WEATHERPROOF		

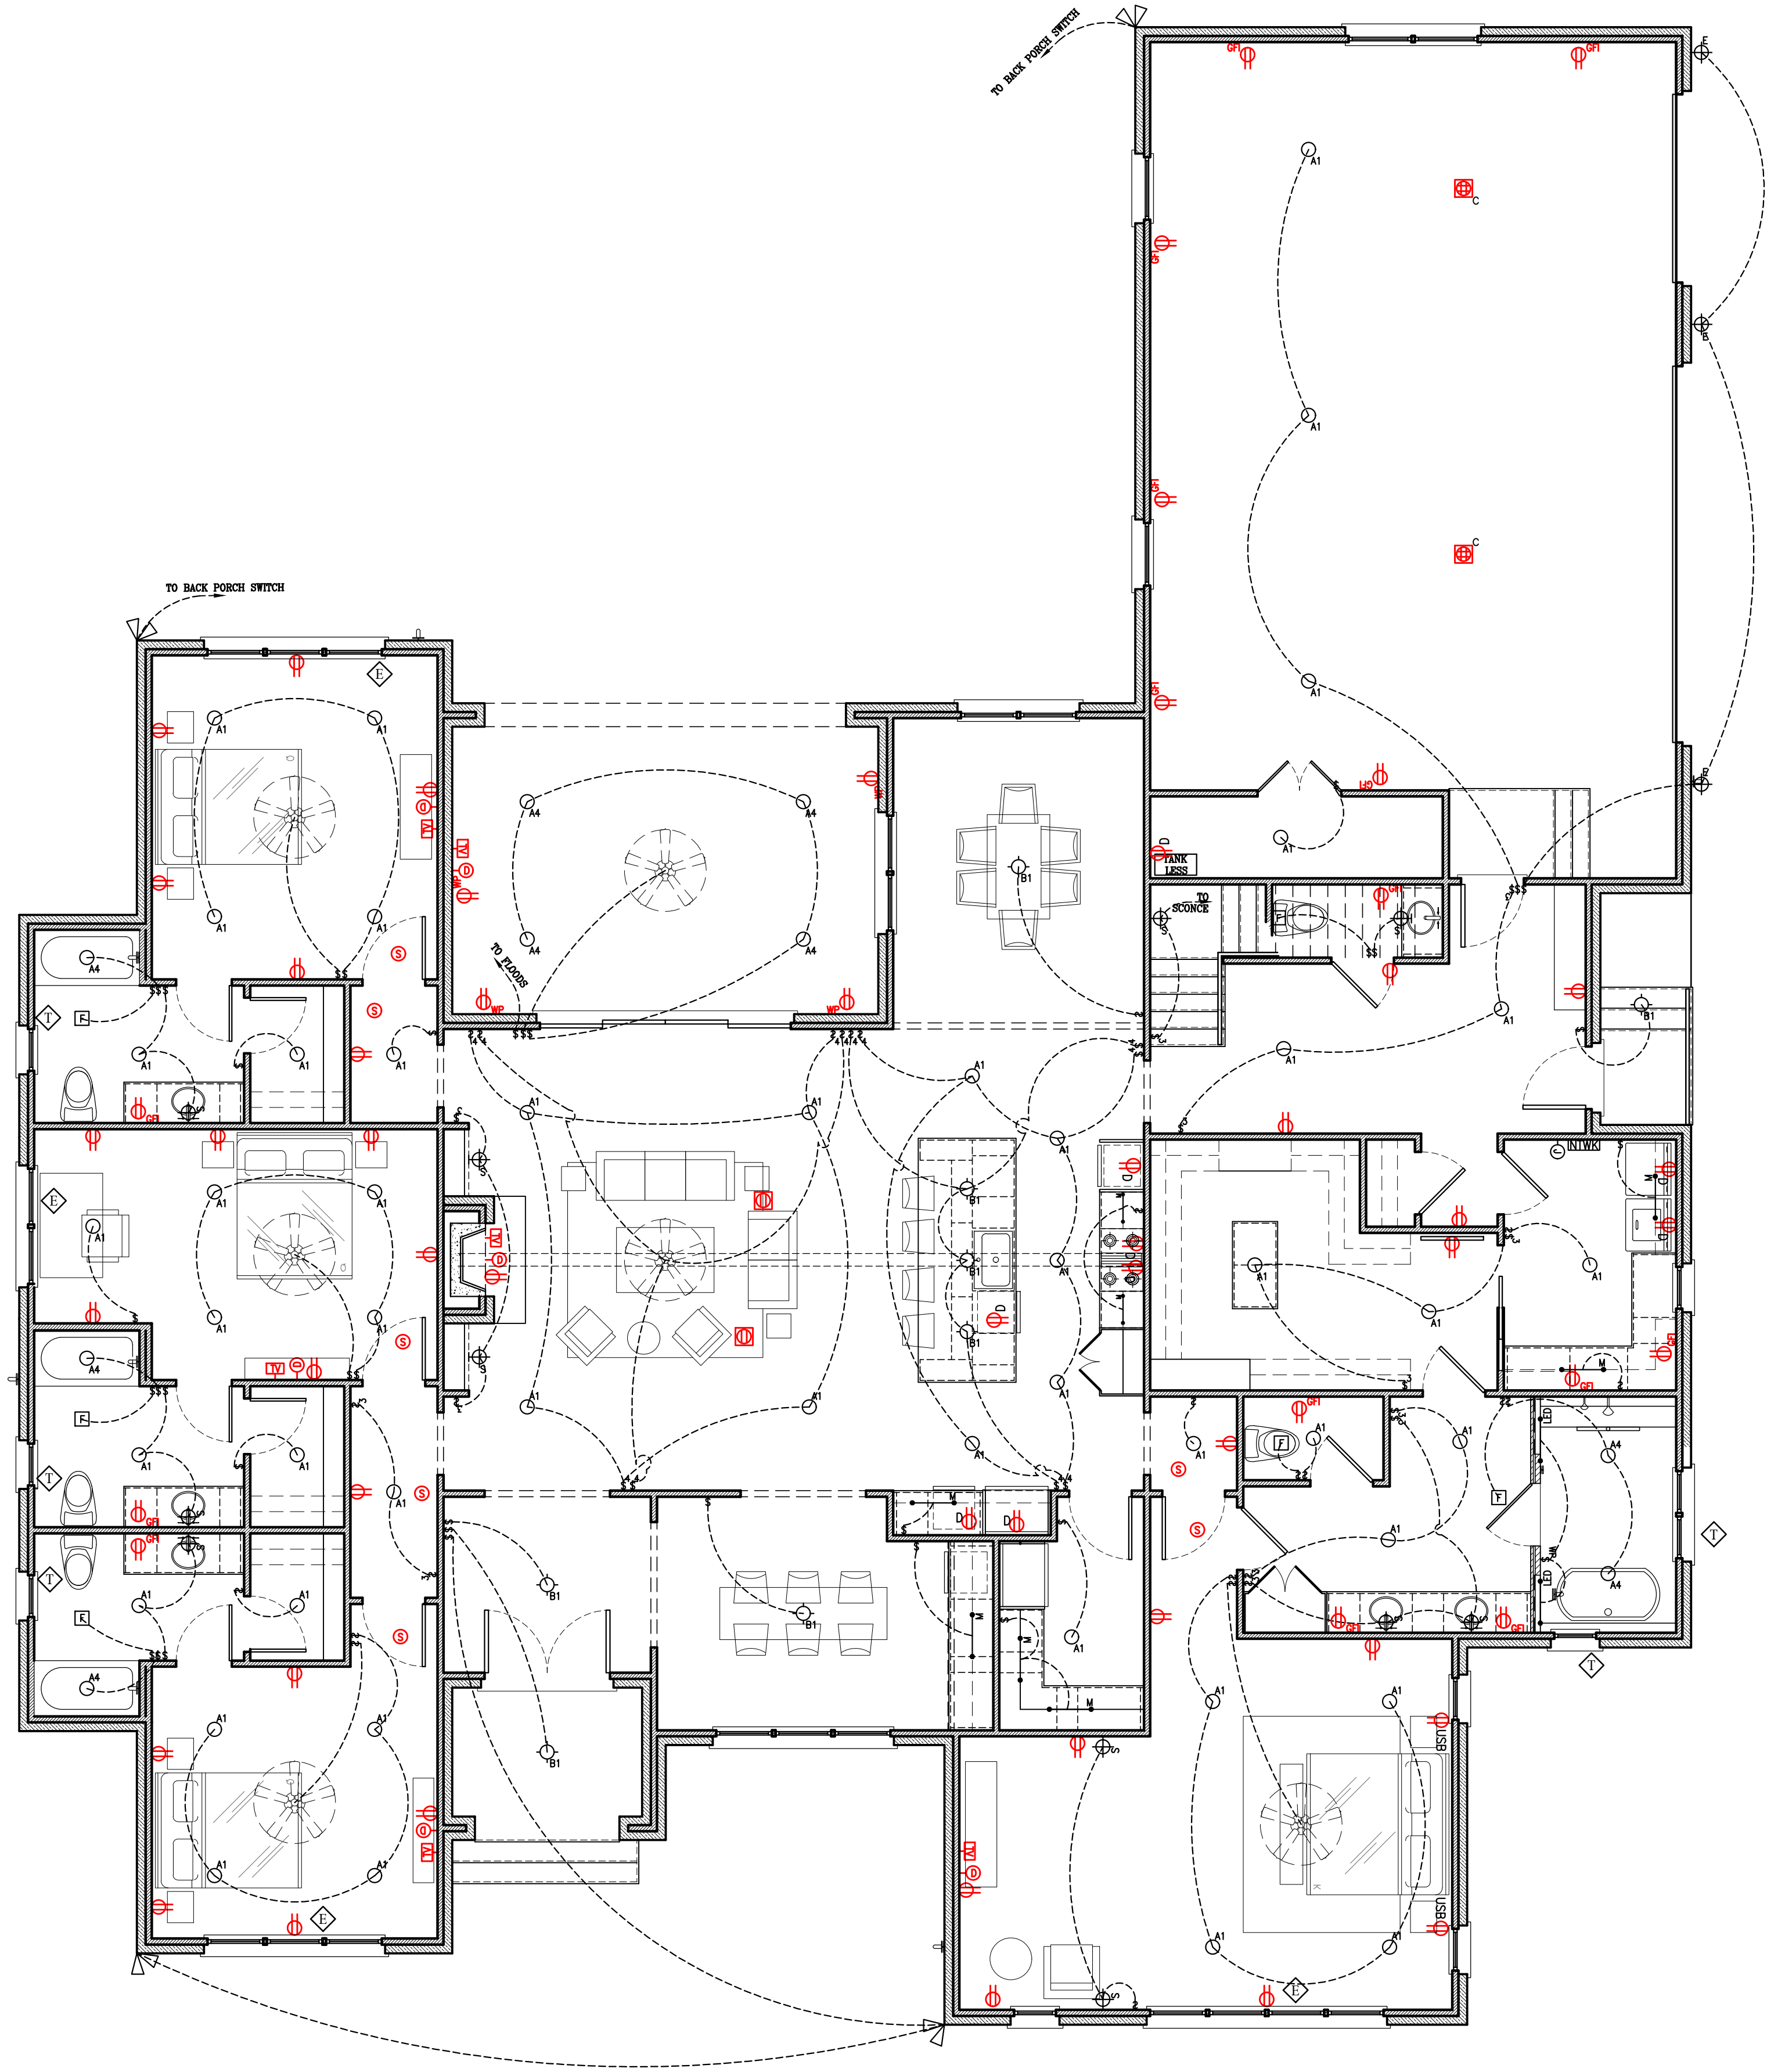

1
L-2.010
MAIN LEVEL ELECTRICAL
SCALE: 1/4" = 1'-0"

REVISION LOG:

NO. DATE REMARKS

DRAWN/CHECKED BY:

TC

MAIN LEVEL ELECTRICAL
FOR
249 EASTON COURT
A NEW RESIDENCE IN
DOTHAN, ALABAMA



R&S CONSTRUCTION
REEVES AND SHAW CONSTRUCTION
Professional Consulting Engineers and Construction Services
3660 West Main Street - Dothan, Alabama 36305 334.677.5600

JOB NUMBER:

DATE:

February 26

SHEET TITLE & NO.

MAIN LEVEL ELECTRICAL

L-2.010

WINDOW SCHEDULE						
MAIN LEVEL						
NUMBER	WIDTH	HEIGHT	HEAD HEIGHT	MATERIAL	DESCRIPTION	NOTES
W101	(3) 2'-8"	6'-6"	8'-0"	AL. CLAD	EGRESS	OPP. CASEMENT
W102	(3) 2'-8"	6'-6"	8'-0"	AL. CLAD		OPP. CASEMENT
W103	2'-0"	3'-6"	6'-0"	AL. CLAD	FIXED	OVAL WINDOW
W104	(4) 2'-8"	6'-6"	8'-0"	AL. CLAD	EGRESS	OPP. CASEMENT
W105	2'-0"	4'-6"	6'-0"	AL. CLAD	FIXED	
W106	2'-0"	4'-6"	6'-0"	AL. CLAD	FIXED	
W107	2'-0"	4'-6"	6'-0"	AL. CLAD	FIXED	TEMPERED, FROSTED GLASS
W108	(2) 2'-0"	4'-6"	6'-0"	AL. CLAD	FIXED	TEMPERED, FROSTED GLASS
W109	2'-0"	3'-6"	6'-0"	AL. CLAD	FIXED	OVAL WINDOW
W110	(2) 3'-0"	6'-0"	8'-0"	AL. CLAD		OPP. CASEMENT
W111	3'-0"	6'-0"	8'-0"	AL. CLAD		OPP. CASEMENT
W112	3'-0"	6'-0"	8'-0"	AL. CLAD		OPP. CASEMENT
W113	(2) 2'-8"	6'-0"	8'-0"	AL. CLAD		OPP. CASEMENT
W114	(2) 2'-8"	6'-0"	8'-0"	AL. CLAD		OPP. CASEMENT
W115	(2) 2'-8"	6'-0"	8'-0"	AL. CLAD	EGRESS	OPP. CASEMENT
W116	2'-0"	4'-6"	6'-0"	AL. CLAD	FIXED	TEMPERED
W117	(2) 2'-8"	6'-0"	8'-0"	AL. CLAD	EGRESS	OPP. CASEMENT
W118	2'-0"	4'-6"	6'-0"	AL. CLAD	FIXED	TEMPERED
W119	2'-0"	4'-6"	6'-0"	AL. CLAD	FIXED	TEMPERED
EXTERIOR DOOR SCHEDULE						
MAIN LEVEL						
NUMBER	WIDTH	HEIGHT	MATERIAL	GLAZING?	DESCRIPTION	NOTES
ED101	(2) 3'-0"	8'-0"	WOOD	YES	HALF GLASS	FRONT FRENCH DOORS
ED102	3'-0"	8'-0"	WOOD	YES	HALF GLASS	SIDE ENTRY DOOR
ED103	3'-0"	8'-0"	FIBERGLASS			GARAGE ENTRY
ED104	18'-0"	8'-0"	FIBERGLASS	YES	QUARTER GLASS	GARAGE DOOR
ED105	9'-0"	8'-0"	FIBERGLASS	YES	QUARTER GLASS	GARAGE DOOR
ED106	12'-0"	8'-0"	FIBERGLASS	YES	4 PANEL DOUBLE SLIDER	
SEE PLAN FOR DOOR SWINGS						
INTERIOR DOOR SCHEDULE						
MAIN LEVEL						
NUMBER	WIDTH	HEIGHT	MATERIAL	GLAZING?	DESCRIPTION	NOTES
ID101	2'-8"	8'-0'	SOLID	NO		
ID102	2'-8"	8'-0'	SOLID	NO		
ID103	3'-0"	8'-0'	SOLID	NO		
ID104	2'-8"	8'-0'	SOLID	NO		
ID105	2'-8"	8'-0'	SOLID	NO		
ID106	3'-0"	8'-0'	SOLID	NO		
ID107	2'-8"	8'-0'	SOLID	NO		
ID108	2'-8"	8'-0'	SOLID	NO		
ID109	3'-0"	8'-0'	SOLID	NO		
ID110	3'-0"	8'-0'	SOLID	NO		
ID111	3'-0"	8'-0'	SOLID	NO		
ID112	3'-0"	8'-0'	SOLID	NO		
ID113	3'-0"	8'-0'	SOLID	NO		
ID114	3'-0"	TBD	GLASS	YES	MASTER SHOWER DOOR	
ID115	3'-0"	8'-0'	SOLID	NO		
ID116	3'-0"	8'-0'	POCKET	NO		
ID117	3'-0"	8'-0'	SOLID	NO		
ID118	3'-0"	8'-0'	SOLID	NO		
ID119	3'-0"	6'-8'	SOLID	NO		
ID120	4'-0"	8'-0'	SOLID	NO	BI-FOLD CLOSET DOORS	
SEE PLAN FOR DOOR SWINGS						
CASED OPENING SCHEDULE						
MAIN LEVEL						
NUMBER	WIDTH	HEIGHT	DEPTH	DESCRIPTION		NOTES
CO101	3'-0"	8'-0'	4"	ARCH		
CO102	3'-0"	8'-0'	4"	ARCH		
CO103	6'-0'	8'-0'	4"			
CO104	6'-0'	8'-0'	4"			
CO105	6'-0'	8'-0'	4"			
CO106	3'-0"	8'-0'	4"	ARCH		
CO107	3'-0"	8'-0'	4"	ARCH		

UPPER LEVEL WINDOW SCHEDULE							
UPPER LEVEL							
NUMBER	WIDTH	HEIGHT	HEAD HEIGHT	MATERIAL	DESCRIPTION	NOTES	
W201	2'-8"	1'-8"	11'-8"	AL. CLAD	FIXED	H.H. MEASURED FROM MAIN LEVEL F.F	
W202	(2) 3'-0"	5'-0"	18'-10"	AL. CLAD	FIXED	H.H. MEASURED FROM MAIN LEVEL F.F	
W203	(3) 2'-8"	1'-8"	11'-8"	AL. CLAD	FIXED	H.H. MEASURED FROM MAIN LEVEL F.F	
W204	2'-6"	4'-4"	6'-8"	AL. CLAD	EGRESS	H.H. MEASURED FROM UPPER LEVEL F.F	
W205	2'-6"	4'-4"	6'-8"	AL. CLAD	EGRESS	H.H. MEASURED FROM UPPER LEVEL F.F	
W206	3'-0"	5'-0"	6'-8"	AL. CLAD	FIXED	H.H. MEASURED FROM UPPER LEVEL F.F	
UPPER LEVEL INTERIOR DOOR SCHEDULE							
UPPER LEVEL							
NUMBER	WIDTH	HEIGHT	MATERIAL	GLAZING?	DESCRIPTION	NOTES	
ID201	3'-0"	6'-8"	SOLID			ATTIC ACCESS	
ID202	3'-0"	6'-8"	SOLID				
ID203	2'-6"	6'-8"	SOLID				
ID204	3'-0"	6'-8"	SOLID				
ID205	4'-0"	6'-8"	SOLID		BI-FOLD CLOSET DOOR		
SEE PLAN FOR DOOR SWINGS							

REVISION LOG:

NO.	DATE	REMARKS

DRAWN/CHECKED BY:

TC

SCHEDULE FOR
249 EASTON COURT
A NEW RESIDENCE IN
DOTHAN, ALABAMA



REEVES & SHAW
CONSTRUCTION

R&S CONSTRUCTION

REEVES AND SHAW CONSTRUCTION

Professional Consulting Engineers and Construction Services
3686 West Main Street - Dothan, Alabama 36505 334.677.5600

JOB NUMBER:

DATE:

February 26

SHEET TITLE & NO.

SCHEDULE

A-8.000

1
A-8.000

SCHEDULE
SCALE: 1'-0" = 1'-0"